


**GENERAL NOTES :**

1. ALL THE DIMENSIONS ARE UNFINISHED DIMENSIONS.
2. ALL DIMENSIONS ARE IN MM AND LEVELS ARE IN MT. UNLESS OTHERWISE MENTIONED.
3. ALL THE DIMENSIONS SHALL BE READ & NOT TO BE MEASURED.
4. IN CASE OF ANY DISCREPANCY, BRING IT TO THE NOTICE OF THE ARCHITECT IMMEDIATELY.
5. DETAIL DRAWING PRECEDES THE GENERAL DRAWING

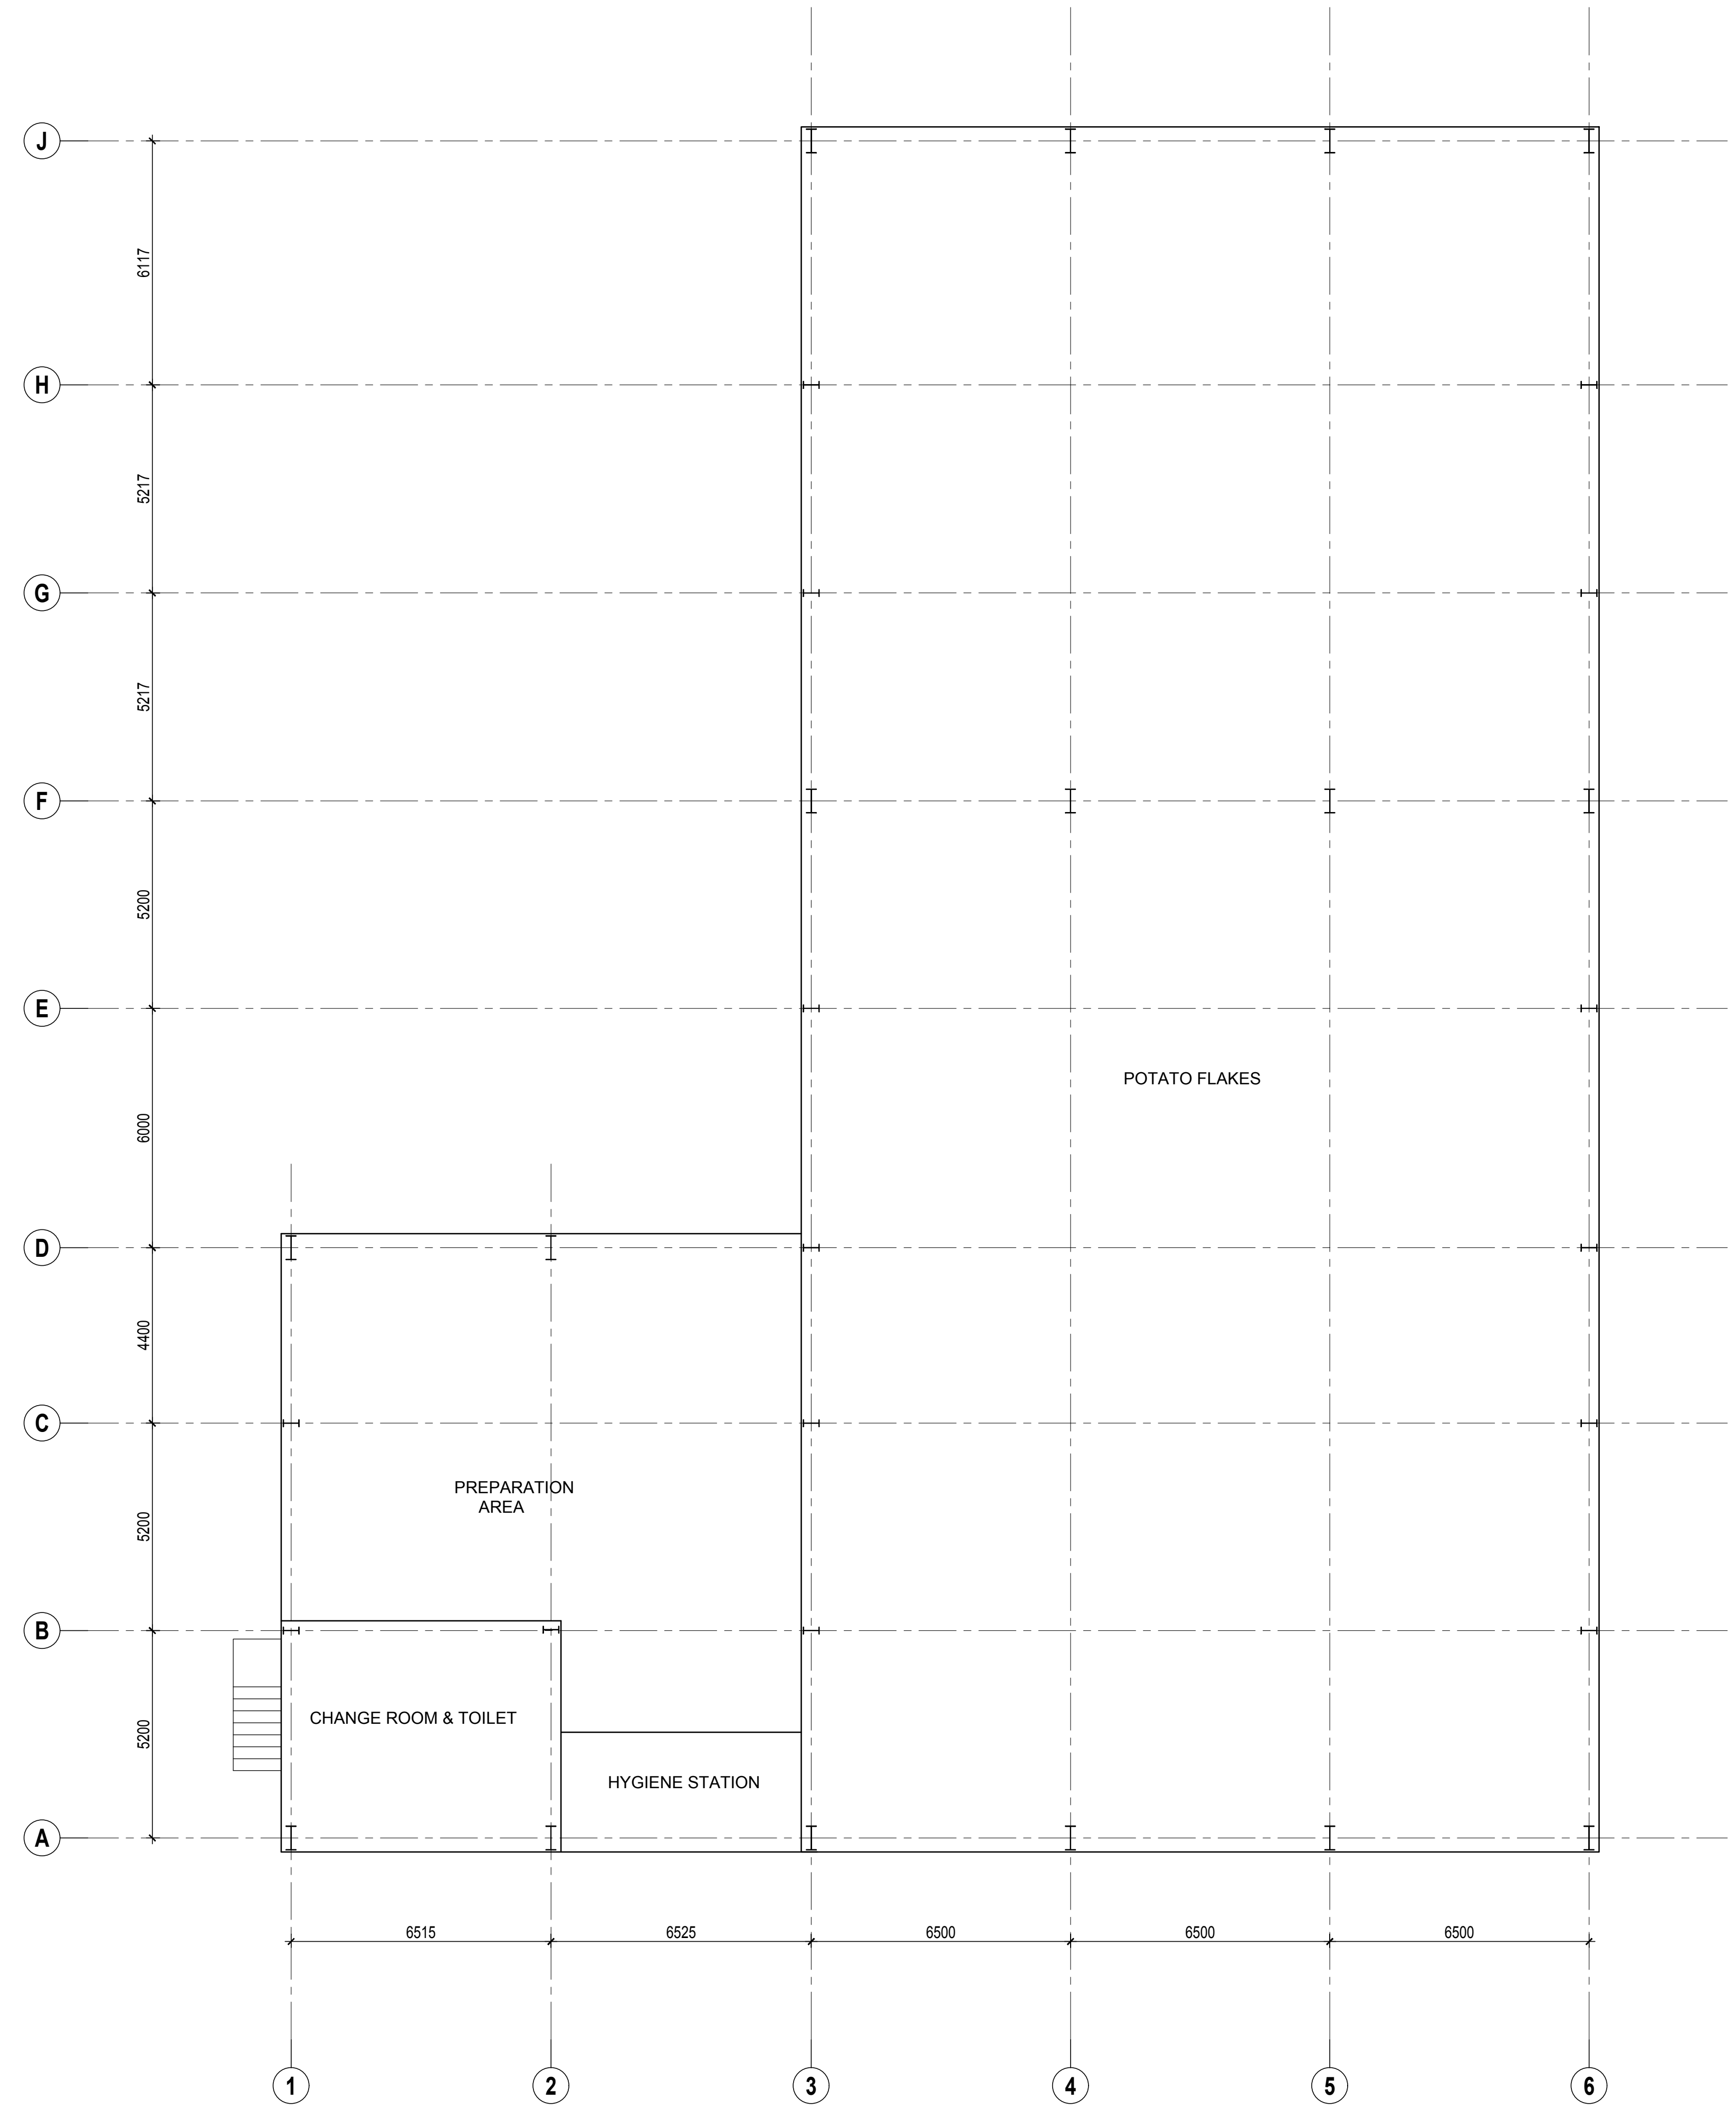

FOR TENDER

NO.	DATE	DESCRIPTION	DRAWN BY	CHECKED BY

**REVISION HISTORY**

KEY PLAN  
SCALE: N.T.S.  
ⓘ

- REFERENCE DRAWINGS :**
- 01. ARCHITECTURAL :-
  - 02. STRUCTURAL :-
  - 03. HVAC :-
  - 04. ELECTRICAL :-
  - 05. UTILITIES :-

**GROUND FLOOR PLAN**  
**POTATO FLAKES AREA**  
PMC  
**Technopak Advisors Pvt. Ltd.**  
**Gurgaon.**



PROJECT NO. <b>2017</b>	SCALE : 1:200	DRAWN : PARESH
DATE : 29-11-2017	APPROVED : NITESH	CHECKED : PARESH
COORDINATION CHECKED: NITESH		

**vms** ENGINEERING & DESIGN SERVICES (P) LTD.  
CHITRAKOOT FLATS, BEHIND TIMES OF INDIA, OFF ASHRAM ROAD,  
AHMEDABAD-380 009. PHONE: +91 (079) 2658-8829/4488, 40236236  
ENGINEERING + ARCHITECTURE FAX : +91 (079) 2658 3596 WWW.VMSCONSULTANTS.COM

SHEET SIZE	DRAWING NO.	TENDER	REVISION:
ⓘ	--- T.M.1.101	T	R0