

THIS DRAWING & DESIGN IS THE SOLE PROPERTY OF VMS & SHALL NOT BE COPIED, TRACED OR REPRODUCED BY ANY MEANS WITHOUT PRIOR WRITTEN CONSENT OF THE FIRM.

GENERAL NOTES :


1. ALL DIMENSIONS ARE IN MM AND LEVELS ARE IN MT, UNLESS OTHERWISE MENTIONED.
2. ALL THE DIMENSIONS SHALL BE READ & NOT TO BE MEASURED.
3. IN CASE OF ANY DISCREPANCY, BRING IT TO THE NOTICE OF THE ARCHITECT IMMEDIATELY.

IMPORTANT NOTES:

ALL WALKABLE CEILING AND WALKWAY LOADING SHALL BE 100KG/M².

LEGEND LIST:

SR.NO.	SYMBOL	DESCRIPTION
01		MECHANICAL PIPE RACK
02		ELECTRICAL CABLE RACK
03		REFRIGERATION PIPE RACK
04		REFRIGERATION CABLE RACK
05		FIRE HYDRANT PIPE
06		PROCESS WATER PIPE
07		SUPPLY AIR DUCT
08		RETURN AIR DUCT
09		900x900 TRAP DOOR
10		EVAPORATOR-1
11		EVAPORATOR-2

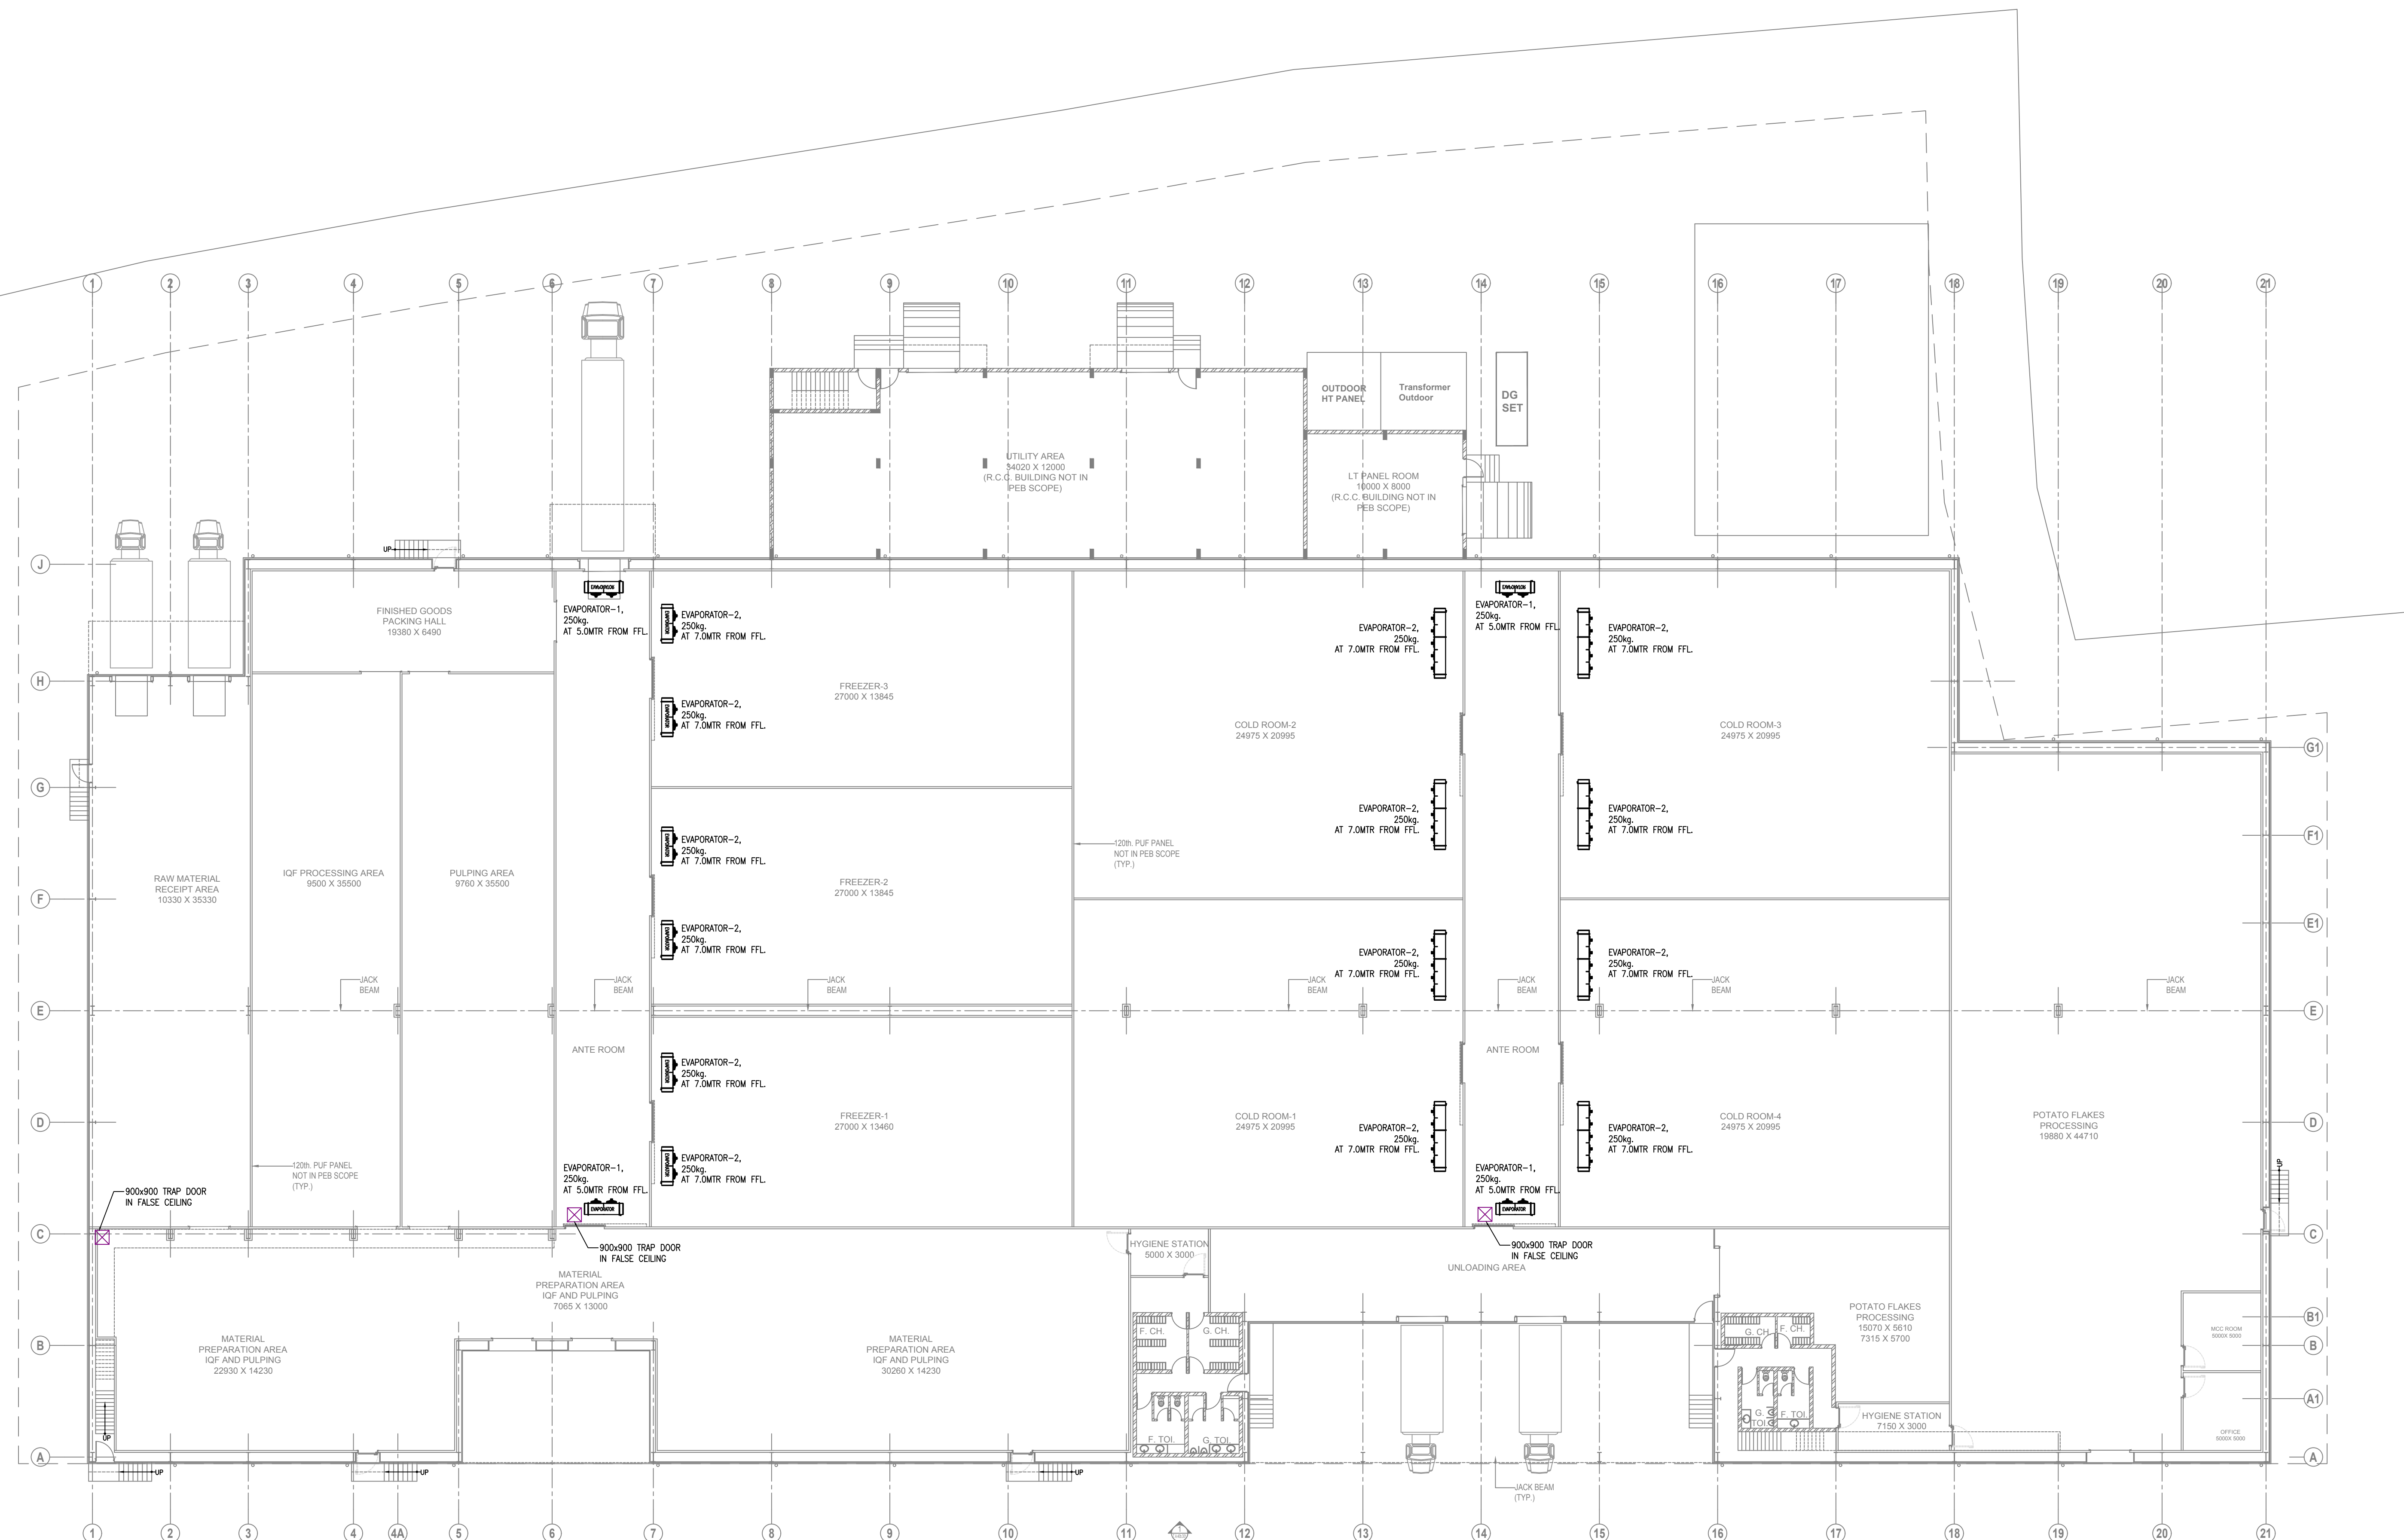

NO.	DATE	DESCRIPTION	DRAWN BY	CHECKED BY
R0	19-01-18	ISSUED FOR REFERENCE	KRUNAL	VIGNESH

REVISION HISTORY

KEY PLAN SCALE: N.T.S.



REFERENCE DRAWINGS :

- 01. ARCHITECTURAL :-
- 02. STRUCTURAL :-
- 03. HVAC :-
- 04. ELECTRICAL :-
- 05. UTILITIES :-

TRAP DOOR & EVAPORATOR LOCATION FOR GROUND FLOOR PLAN CP AREA

PMC
Technopak Advisors Pvt. Ltd. Gurgaon.

fanidhar
MEGA FOOD PARK – AT MUDARDA, MEHSANA
kheth se bazaar tak

PROJECT NO.	SCALE :	DRAWN :	KRUNAL
2017	1:200	CHECKED:	VIGNESH
DATE :	19-01-2018	APPROVED:	NANCY
		COORDINATION CHECKED:	ROMIL

vms VMS ENGINEERING & DESIGN SERVICES (P) LTD.
CHITRAKOOT FLATS, BEHIND TIMES OF INDIA, OFF ASHRAM ROAD,
AHMEDABAD-380 009. PHONE: +91 (079) 2658-8239/4488, 40238236
ENGINEERING + ARCHITECTURE FAX: +91 (079) 2658 3598 WWW.VMSCONSULTANTS.COM

SHEET SIZE	DRAWING NO.	TENDER	REVISION:
600x1000	TM.40B.102	T	R0