


THIS DRAWING & DESIGN IS THE SOLE PROPERTY OF VMS & SHALL NOT BE COPIED, TRACED OR REPRODUCED BY ANY MEANS WITHOUT PRIOR WRITTEN CONSENT OF THE FIRM.

GENERAL NOTES :

1. ALL DIMENSIONS ARE IN MM AND LEVELS ARE IN MT, UNLESS OTHERWISE MENTIONED.
2. ALL THE DIMENSIONS SHALL BE READ & NOT TO BE MEASURED.
3. IN CASE OF ANY DISCREPANCY, BRING IT TO THE NOTICE OF THE ARCHITECT IMMEDIATELY.
4. TRAP STATION AT EVERY 30M+ TO BE ADDED ON STEAM PIPING.
5. EXPANSION LOOP AT EVERY 30M+ TO BE ADDED IN STEAM PIPING.


LEGENDS:

SR.NO.	SYMBOL	DESCRIPTION
01	PRB	PRESSURE REDUCING STATION
02	---	HIGH PRESSURE STEAM
03	---	MEDIUM PRESSURE STEAM
04	---	LOW PRESSURE STEAM
05	---	CONDENSATE RECOVERY
06	---	PROCESS AIR
07	---	INSTRUMENT AIR
08	---	PROCESS WATER
09	---	RO WATER
10	---	HOT PIPE
11	SV	BALL VALVE
12	BT	BUTTERFLY VALVE
13	ADT	AUTOMATIC DRAIN TRAP

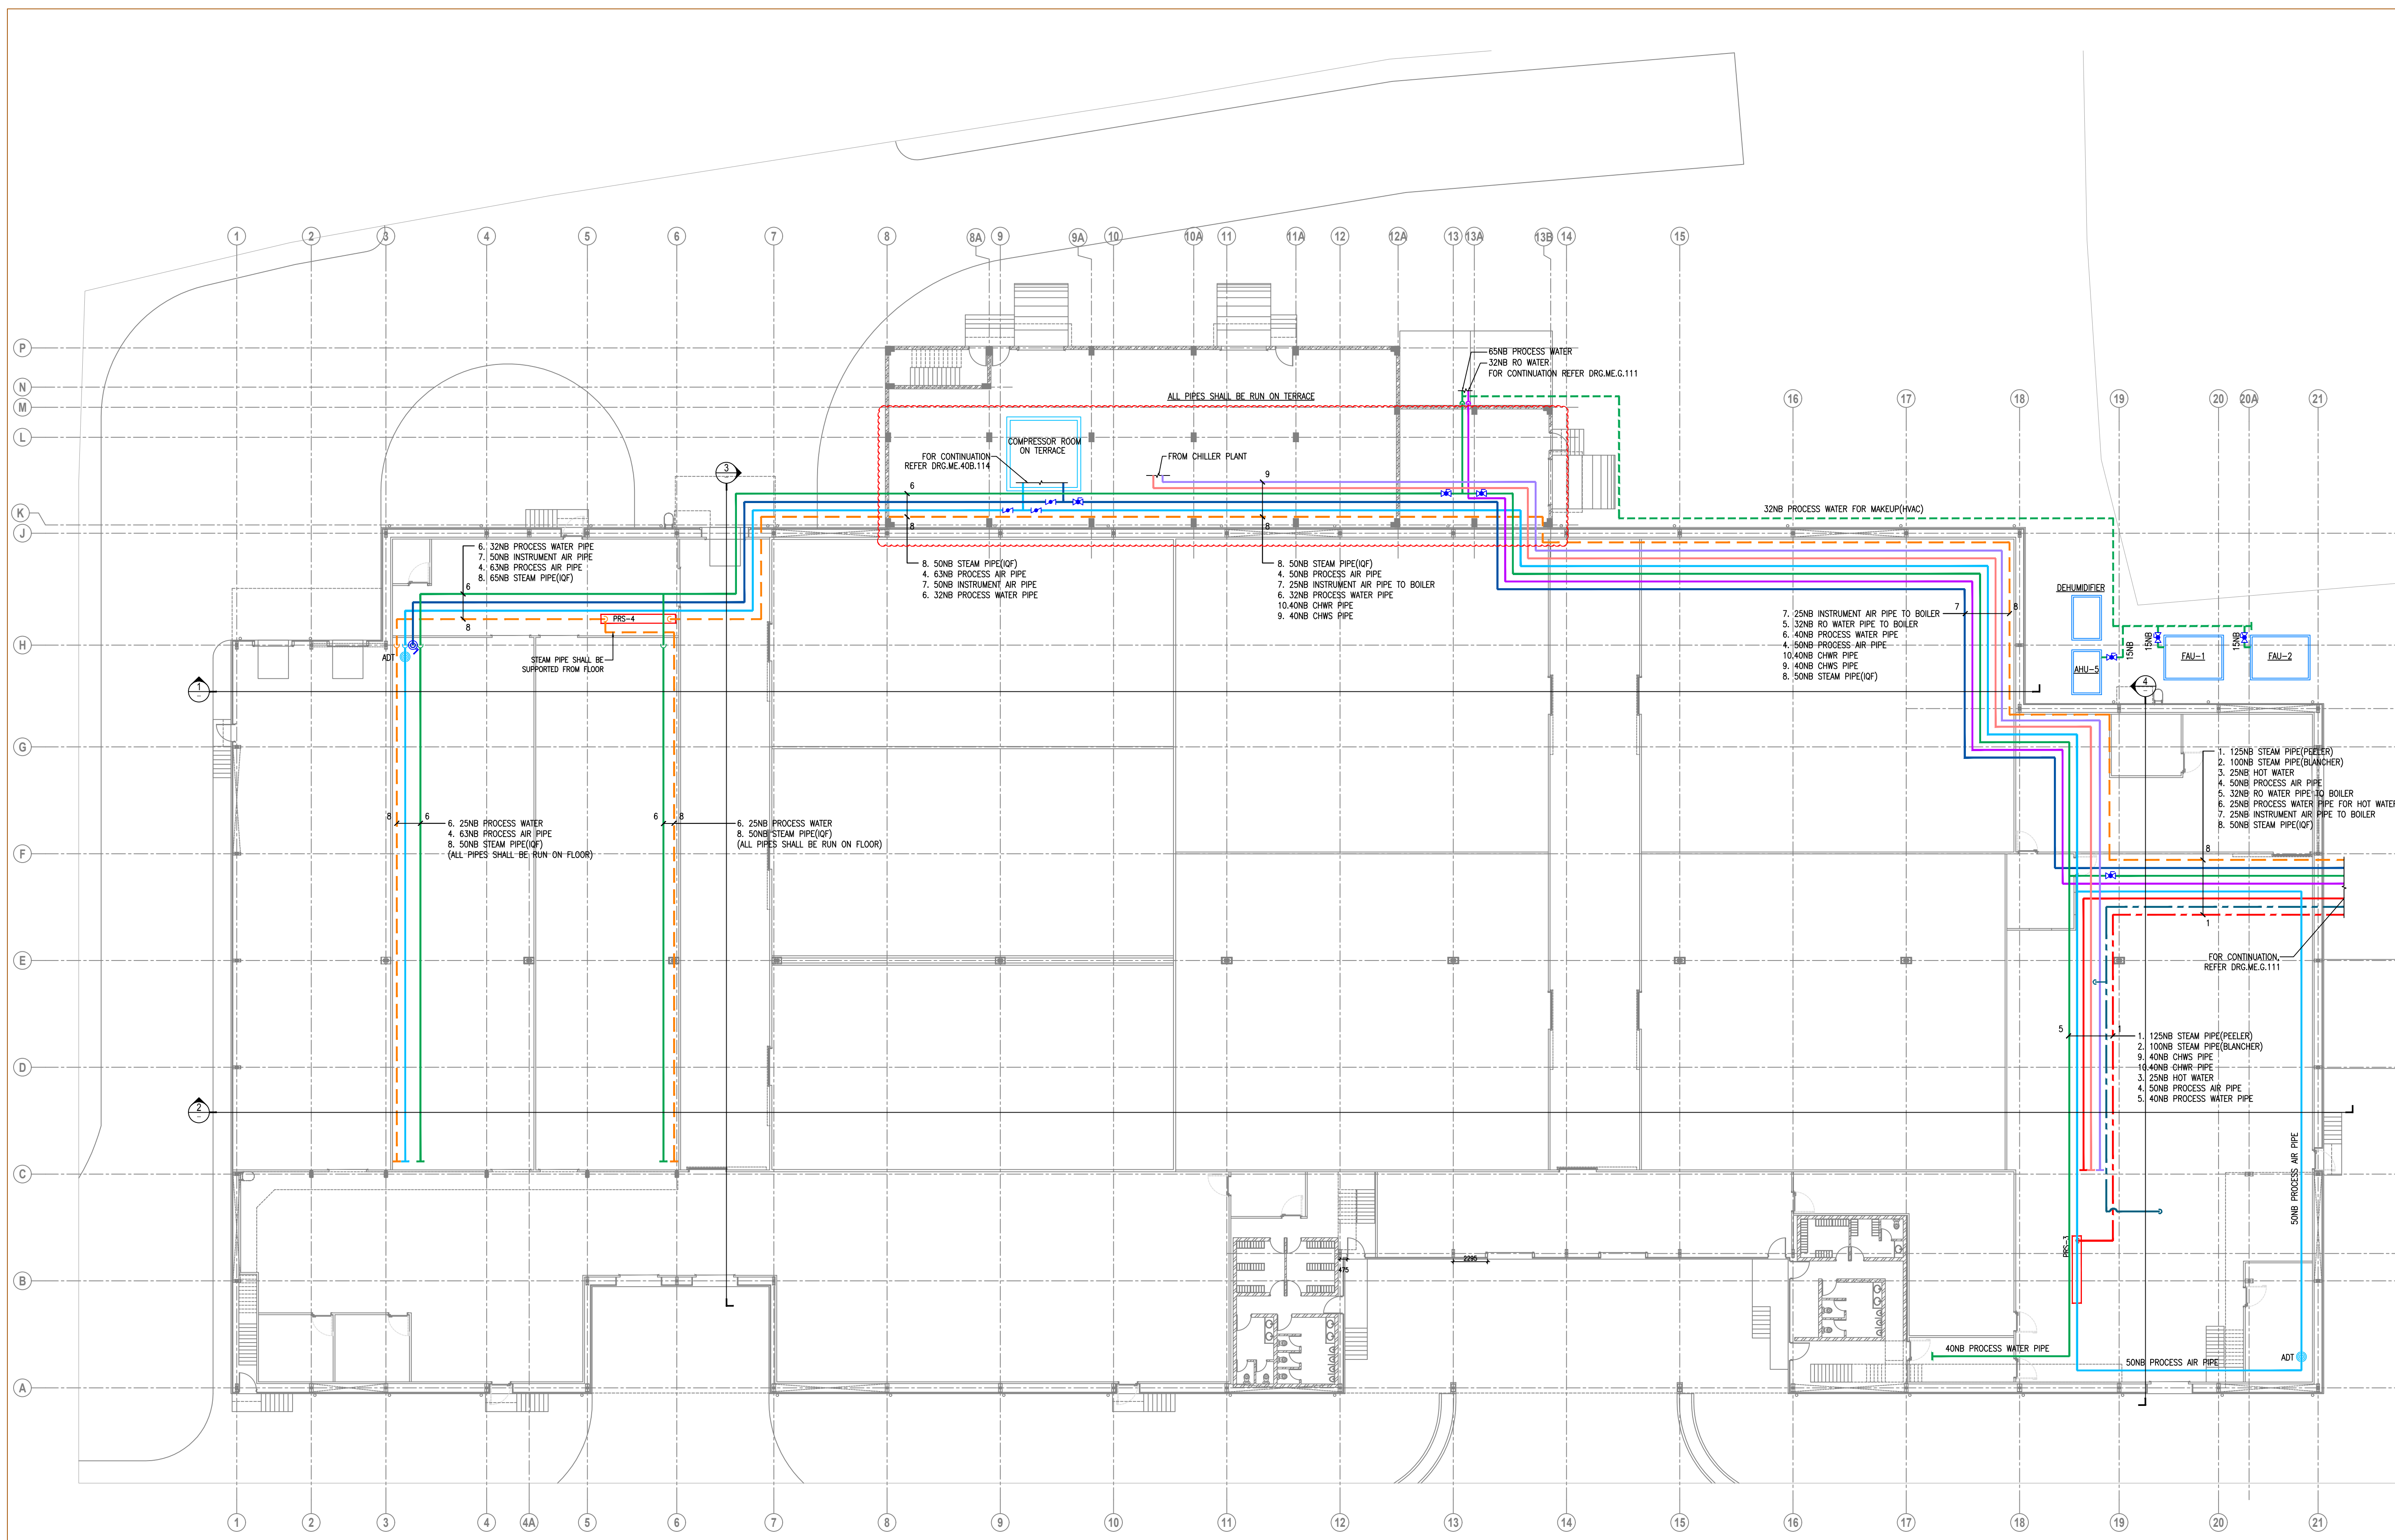

NO.	DATE	DESCRIPTION	DRAWN BY	CHECKED BY
R0	28-05-19	ISSUED FOR TENDER	KRUNAL	MEET

REVISION HISTORY

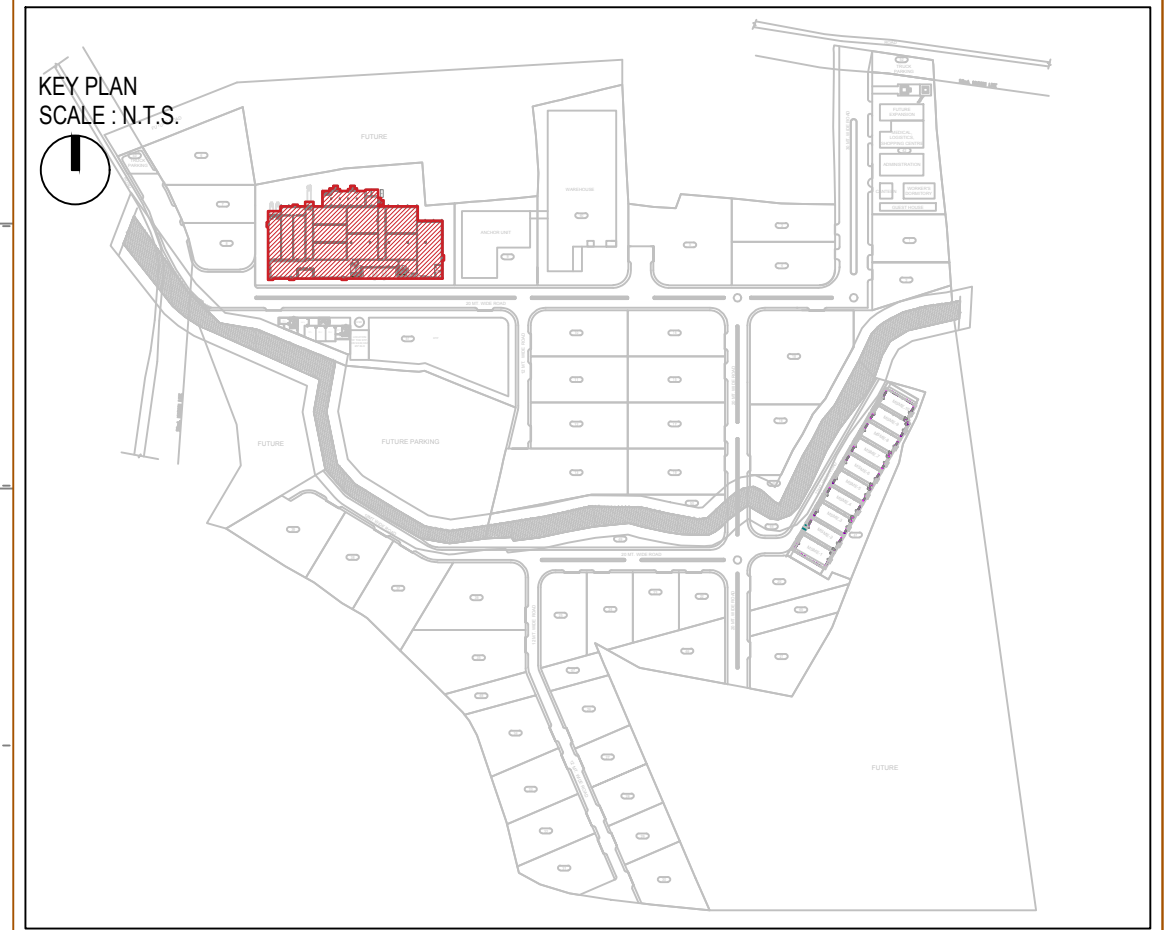

- REFERENCE DRAWINGS :
- 01. ARCHITECTURAL :-
  - 02. STRUCTURAL :-
  - 03. HVAC :-
  - 04. ELECTRICAL :-
  - 05. UTILITIES :-

UTILITY PIPING LAYOUT FOR GROUND FLOOR

CP AREA

PMC  
**Technopak Advisors Pvt. Ltd.**  
**Gurgaon.**

**fanidhar**  
**MEGA FOOD PARK - AT MUDARDA, MEHSANA**  
*khut so bazaar tak...*

PROJECT NO.	SCALE :	DRAWN :	KRUNAL
2017	1:200	CHECKED:	MEET
DATE :	28-05-2019	APPROVED:	ATUL
		COORDINATION CHECKED:	NITESH

**vms** VMS ENGINEERING & DESIGN SERVICES (P) LTD.  
 CHITRAKOOT FLATS, BEHIND TIMES OF INDIA, OFF ASHRAM ROAD,  
 AHMEDABAD-380 009. PHONE: +91 (079) 2658-8829/4488, 40238236  
 FAX: +91 (079) 2658 3598 WWW.VMSCONSULTANTS.COM

SHEET SIZE	DRAWING NO.	RELEASED FOR	REVISION:
600x1000	ME.40B.111	T	R0

**A GROUND FLOOR PLAN**  
 SCALE 1:200