






THIS DRAWING & DESIGN IS THE SOLE PROPERTY OF VMS & SHALL NOT BE COPIED, TRACED OR REPRODUCED BY ANY MEANS WITHOUT PRIOR WRITTEN CONSENT OF THE FIRM.

GENERAL NOTES :


1. ALL DIMENSIONS ARE IN MM AND LEVELS ARE IN MT, UNLESS OTHERWISE MENTIONED.
2. ALL THE DIMENSIONS SHALL BE READ & NOT TO BE MEASURED.
3. IN CASE OF ANY DISCREPANCY, BRING IT TO THE NOTICE OF THE ARCHITECT IMMEDIATELY.
4. TRAP STATION AT EVERY 30M; TO BE ADDED ON STEAM PIPING.
5. EXPANSION LOOP AT EVERY 30M; TO BE ADDED IN STEAM PIPING.

LEGENDS:

SR.NO.	SYMBOL	DESCRIPTION
01		PRESSURE REDUCING STATION
02		HIGH PRESSURE STEAM
03		MEDIUM PRESSURE STEAM
04		LOW PRESSURE STEAM
05		CONDENSATE RECOVERY
06		PROCESS AIR
07		INSTRUMENT AIR
08		PROCESS WATER
09		RO WATER
10		HOT PIPE
11		BALL VALVE
12		BUTTERFLY VALVE
13		AUTOMATIC DRAIN TRAP

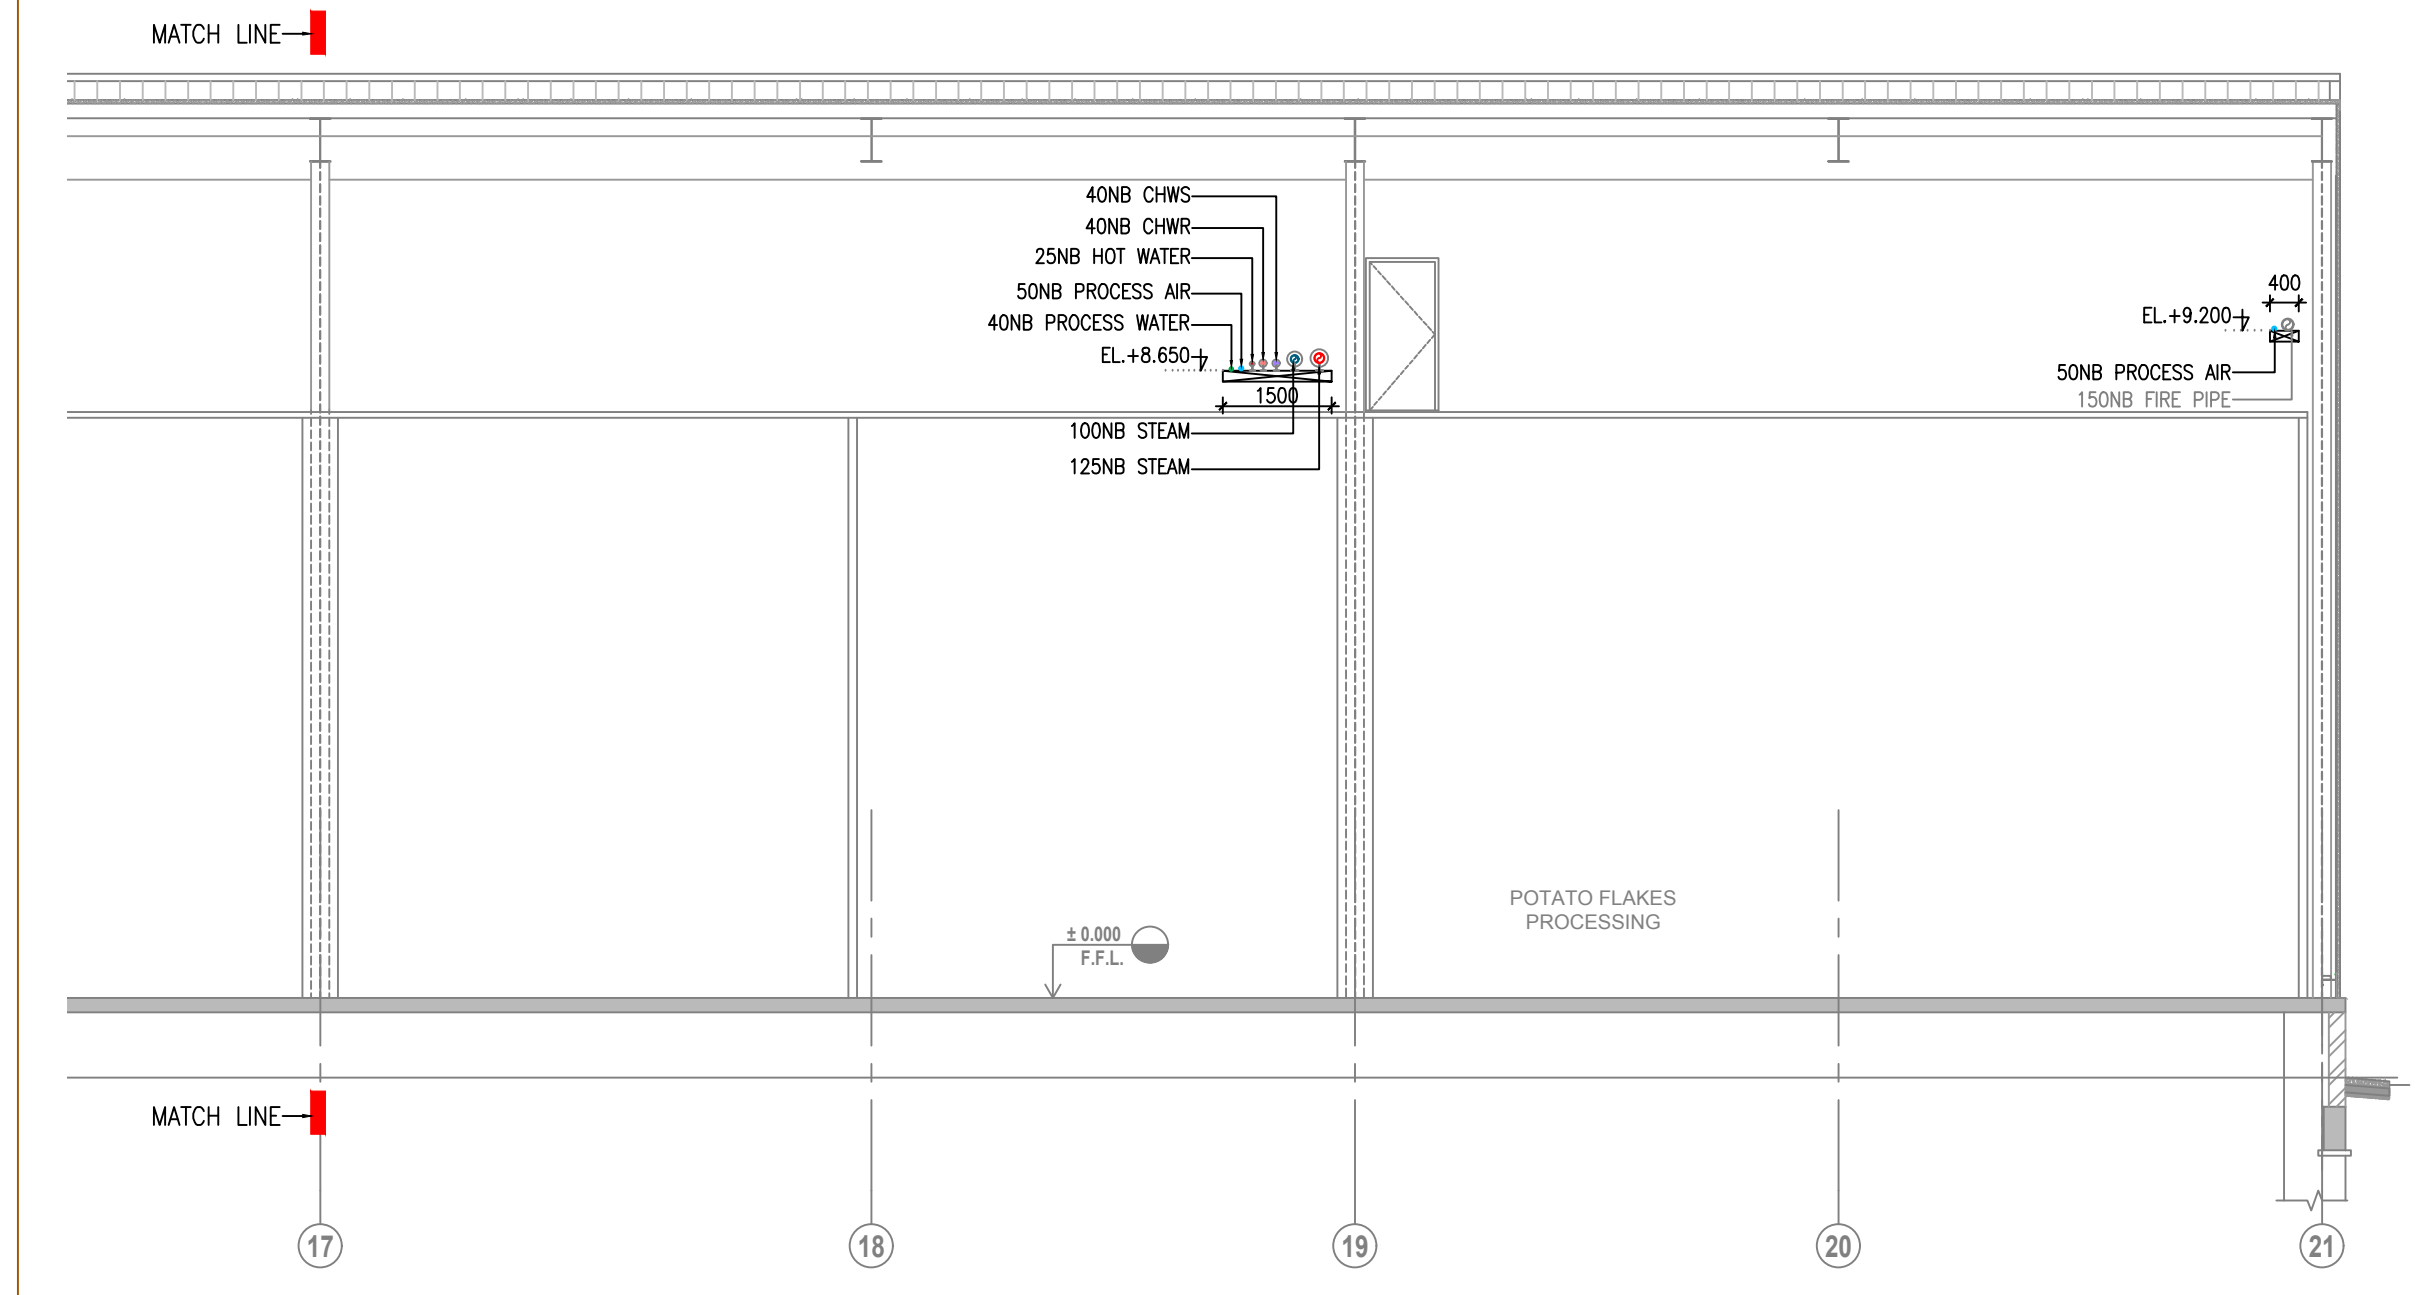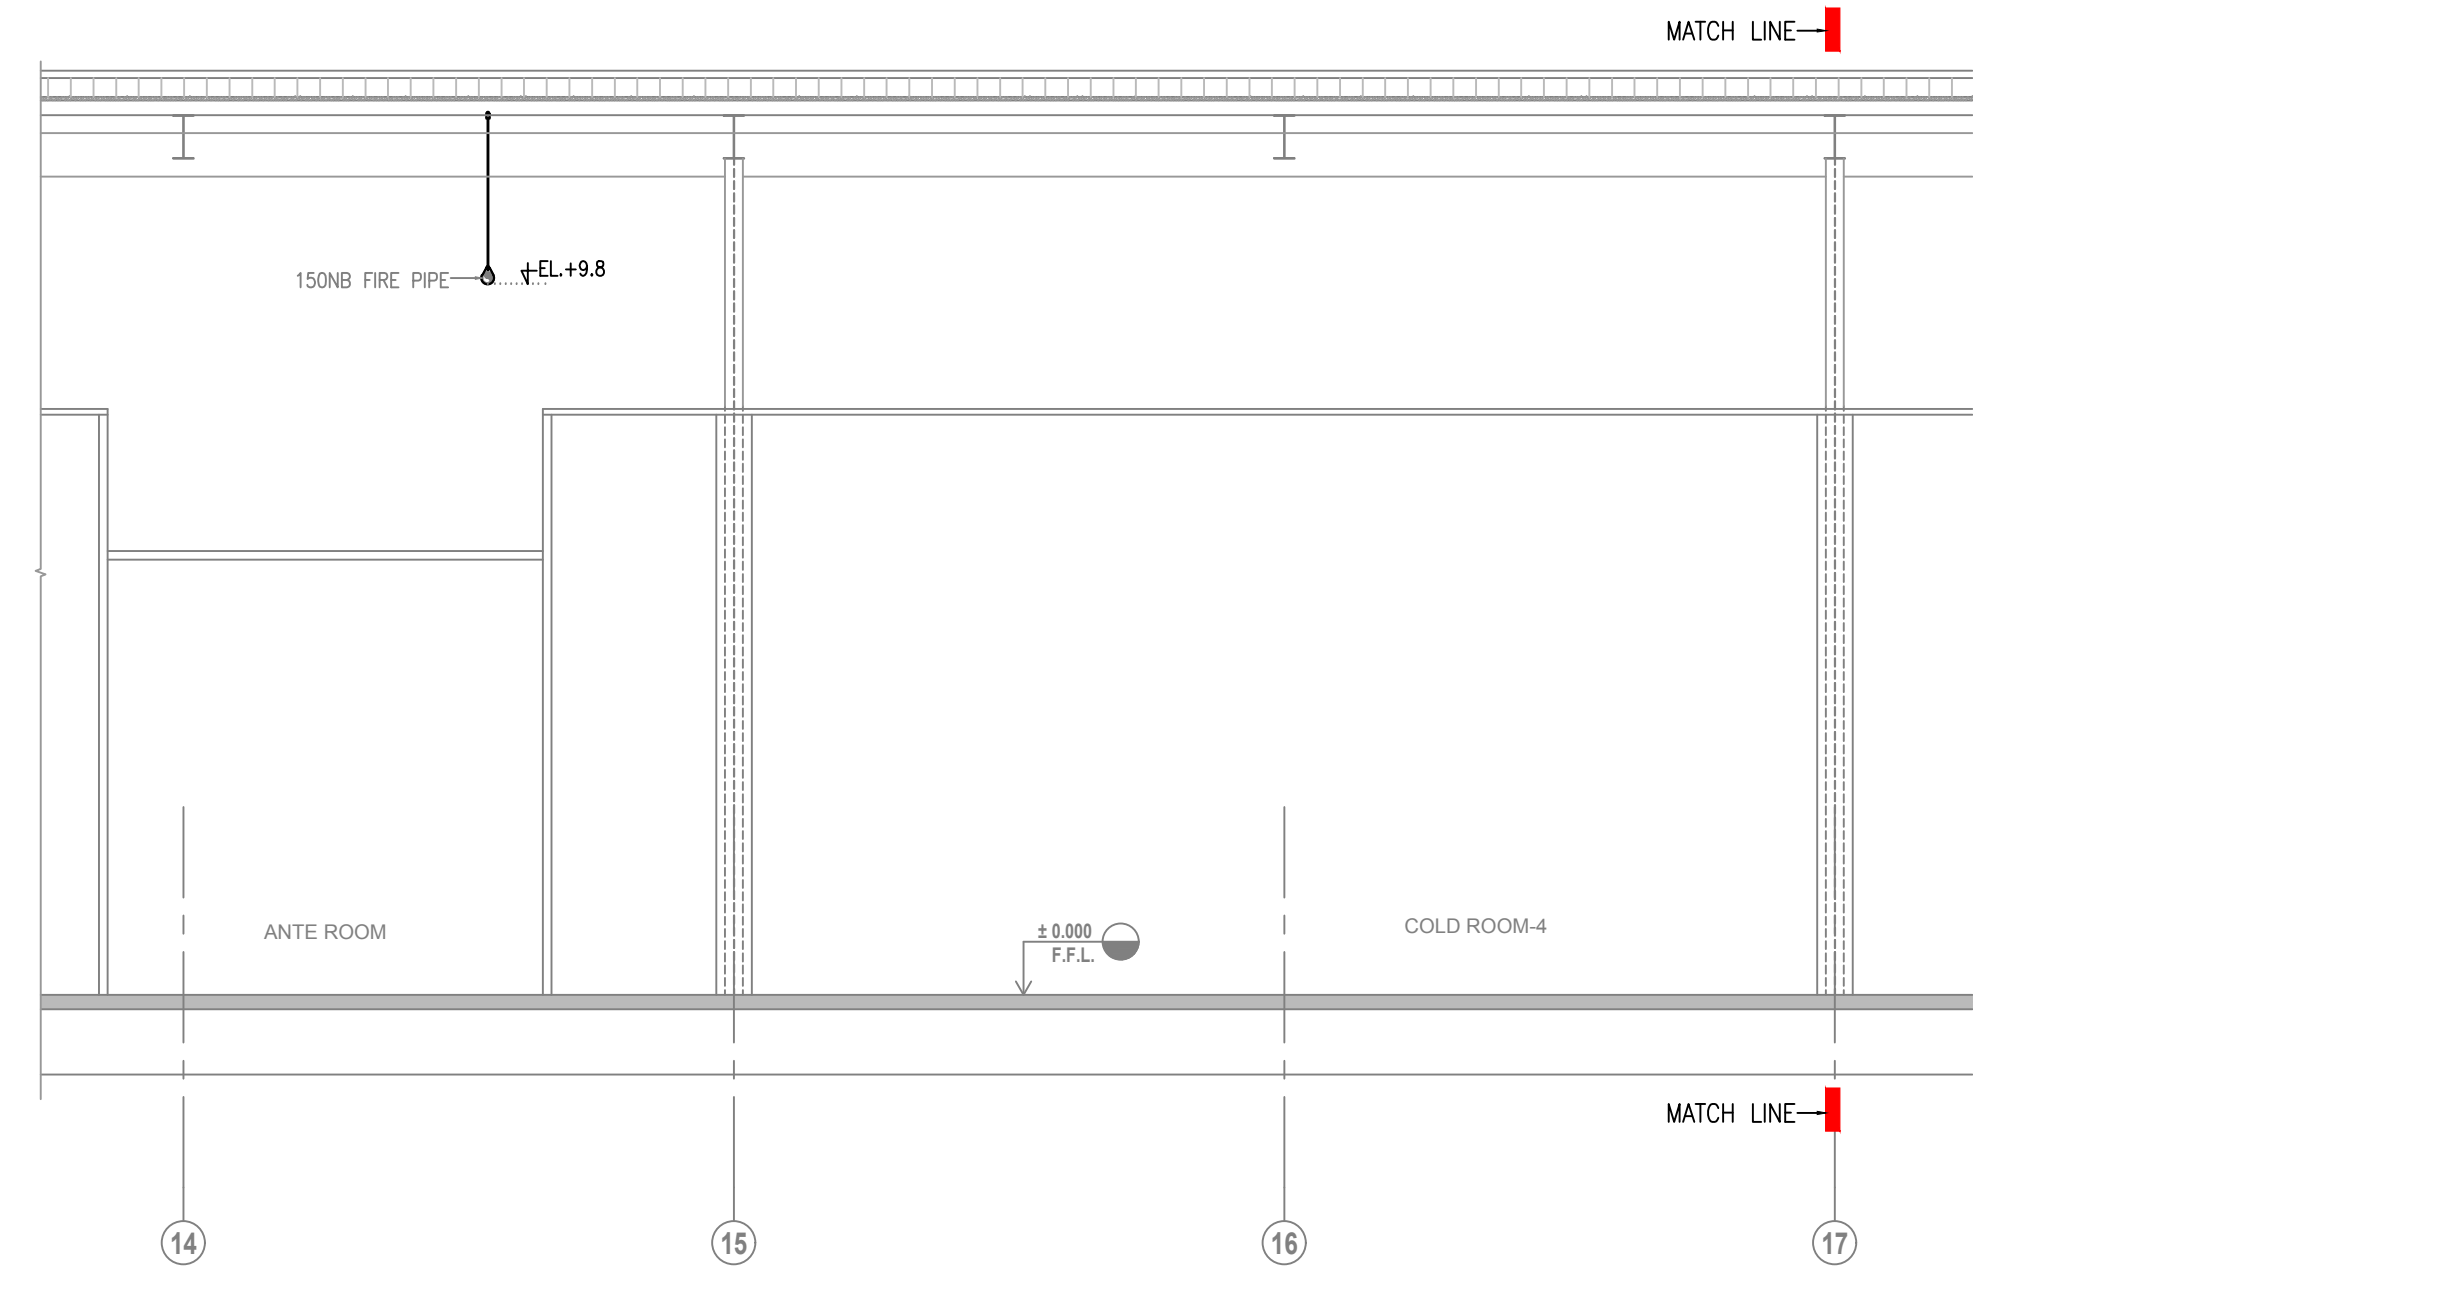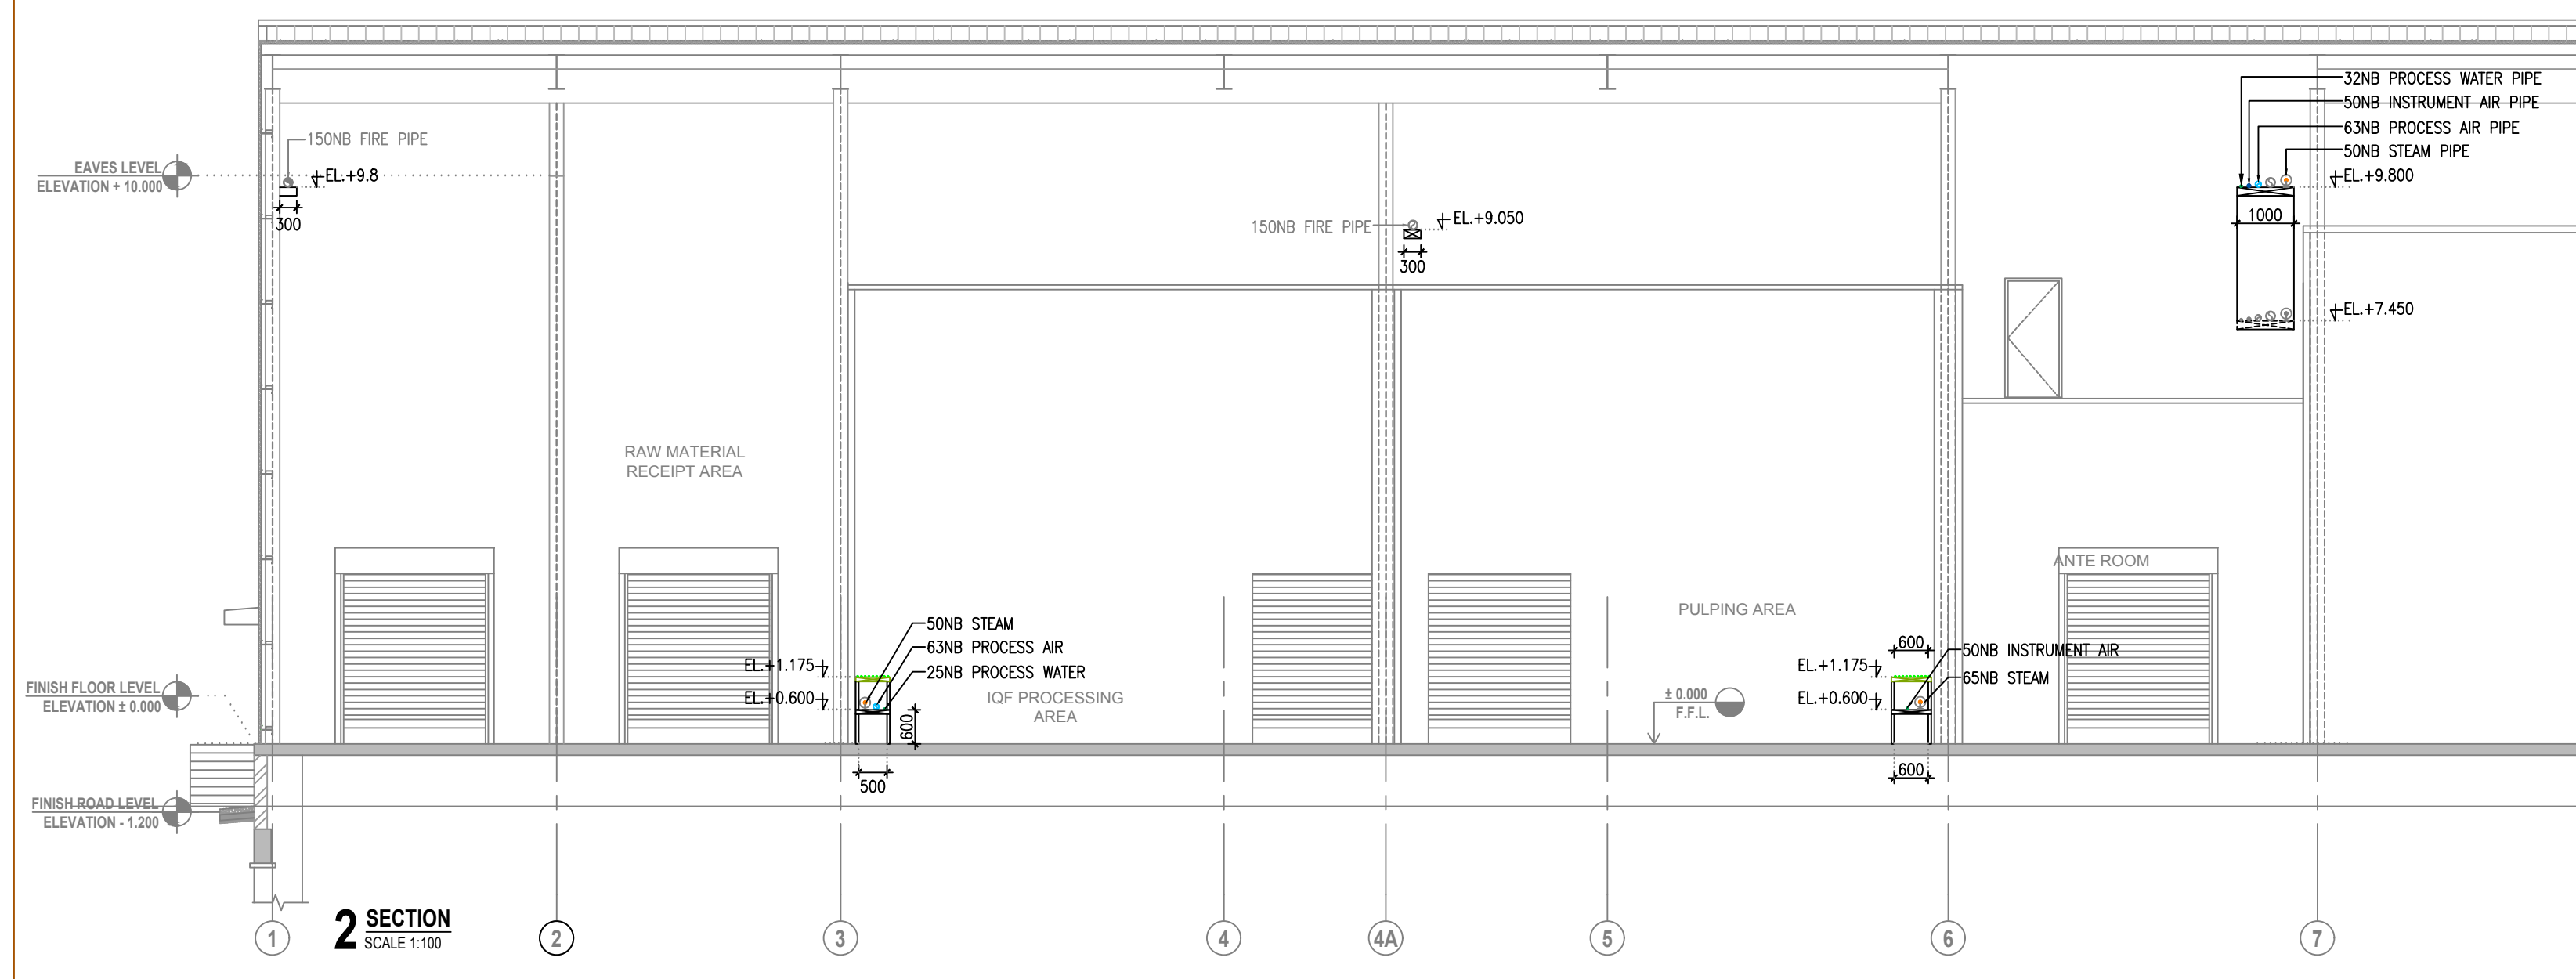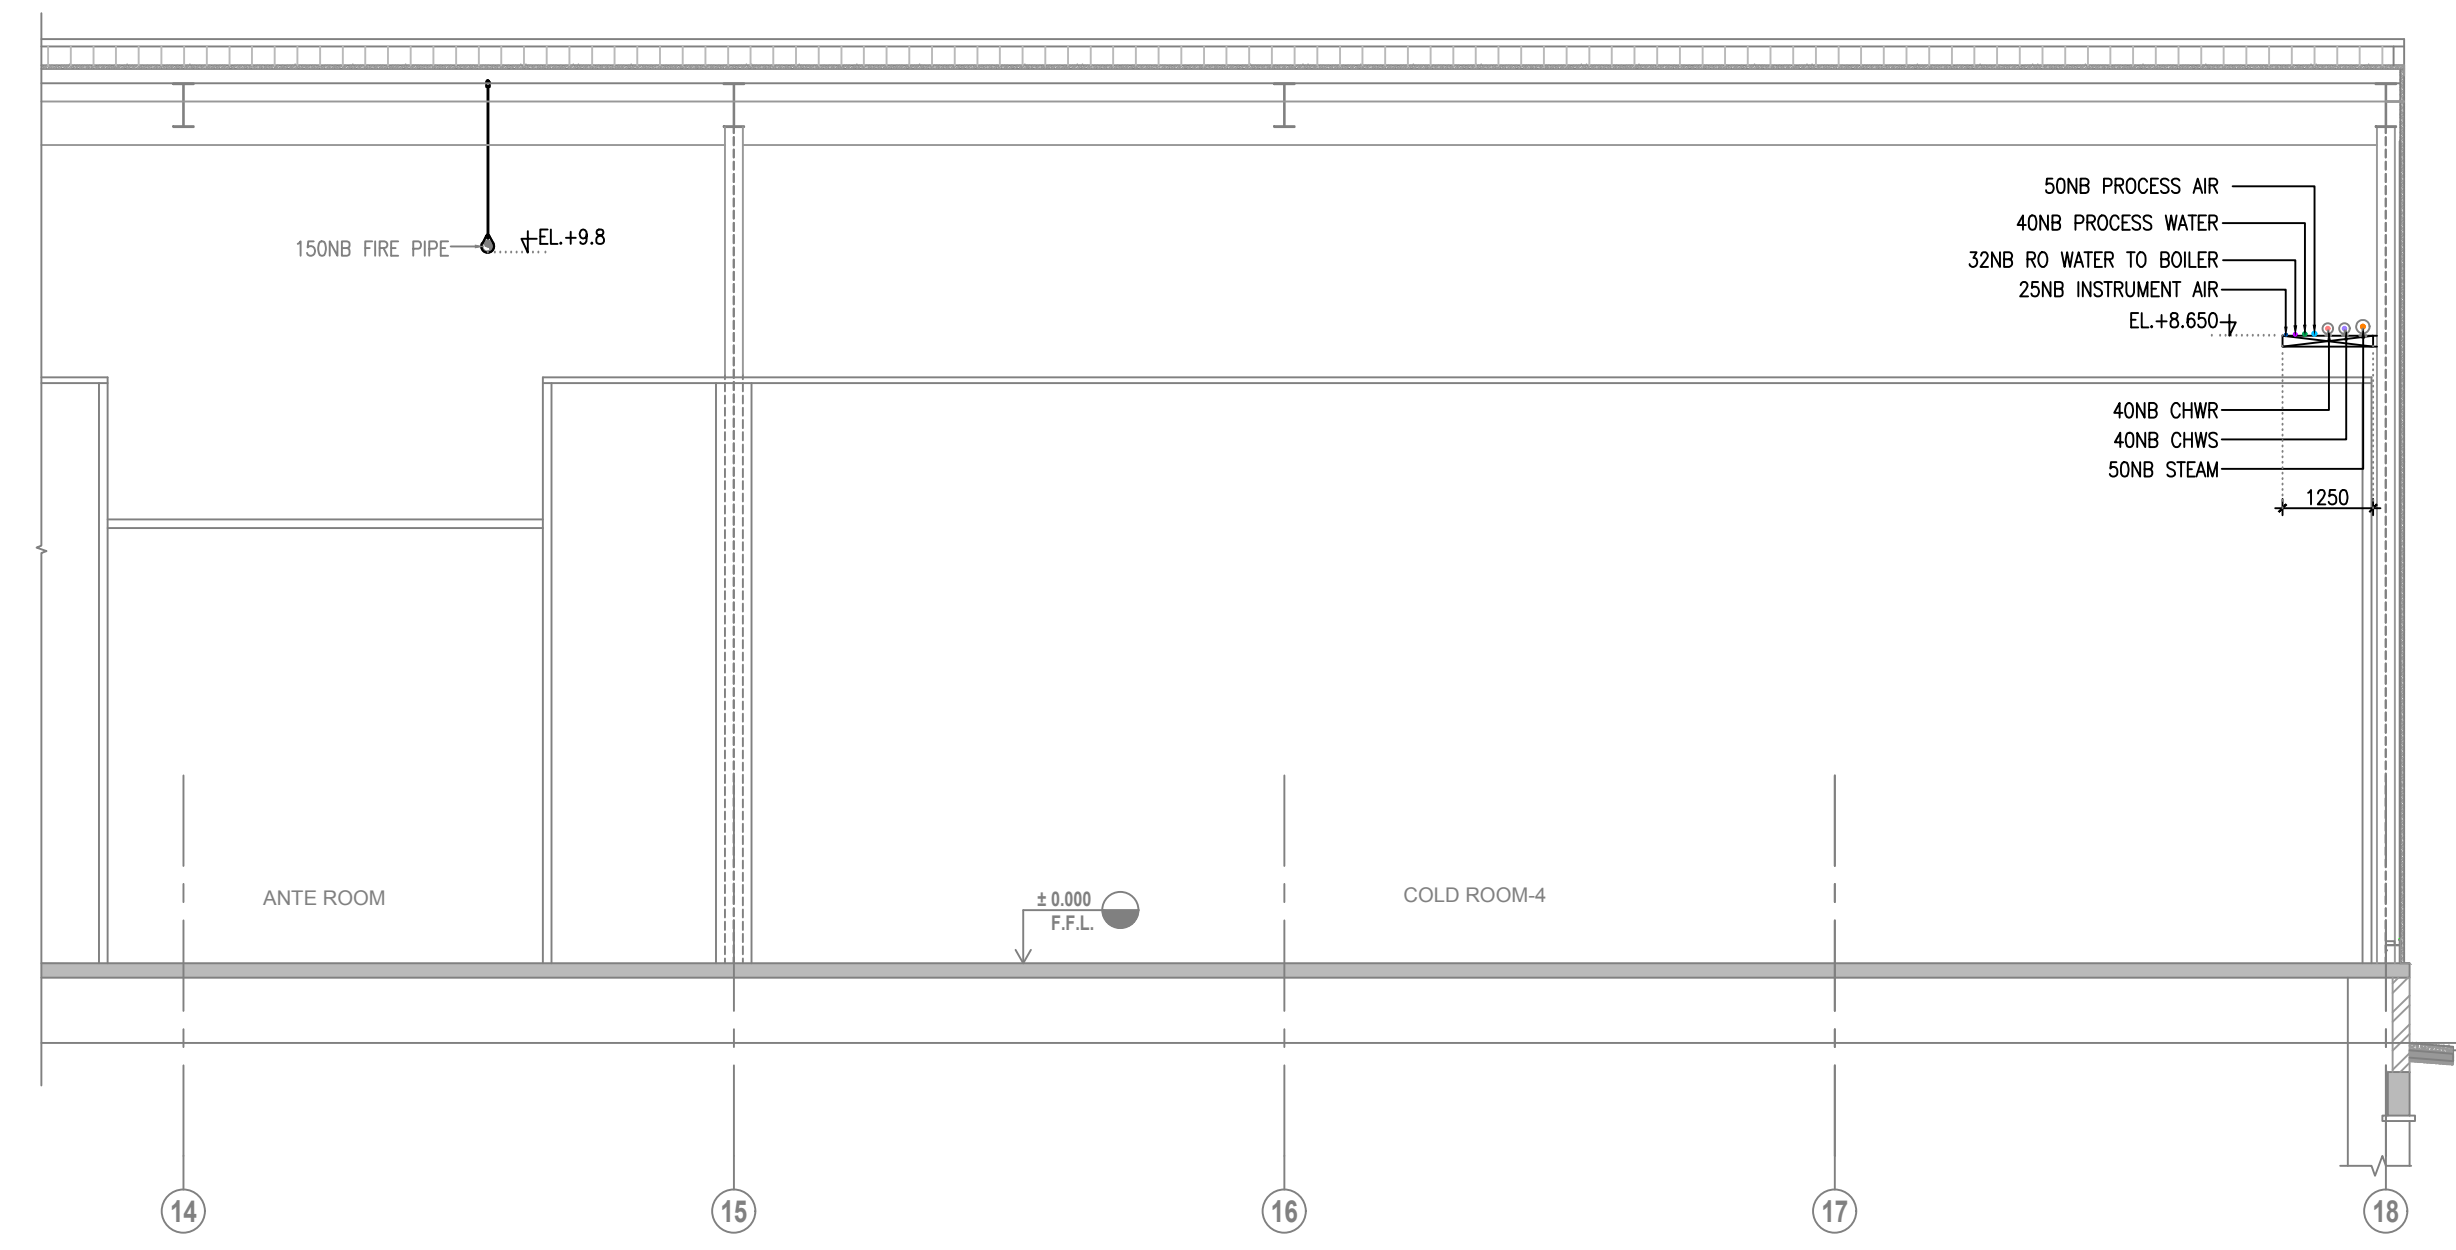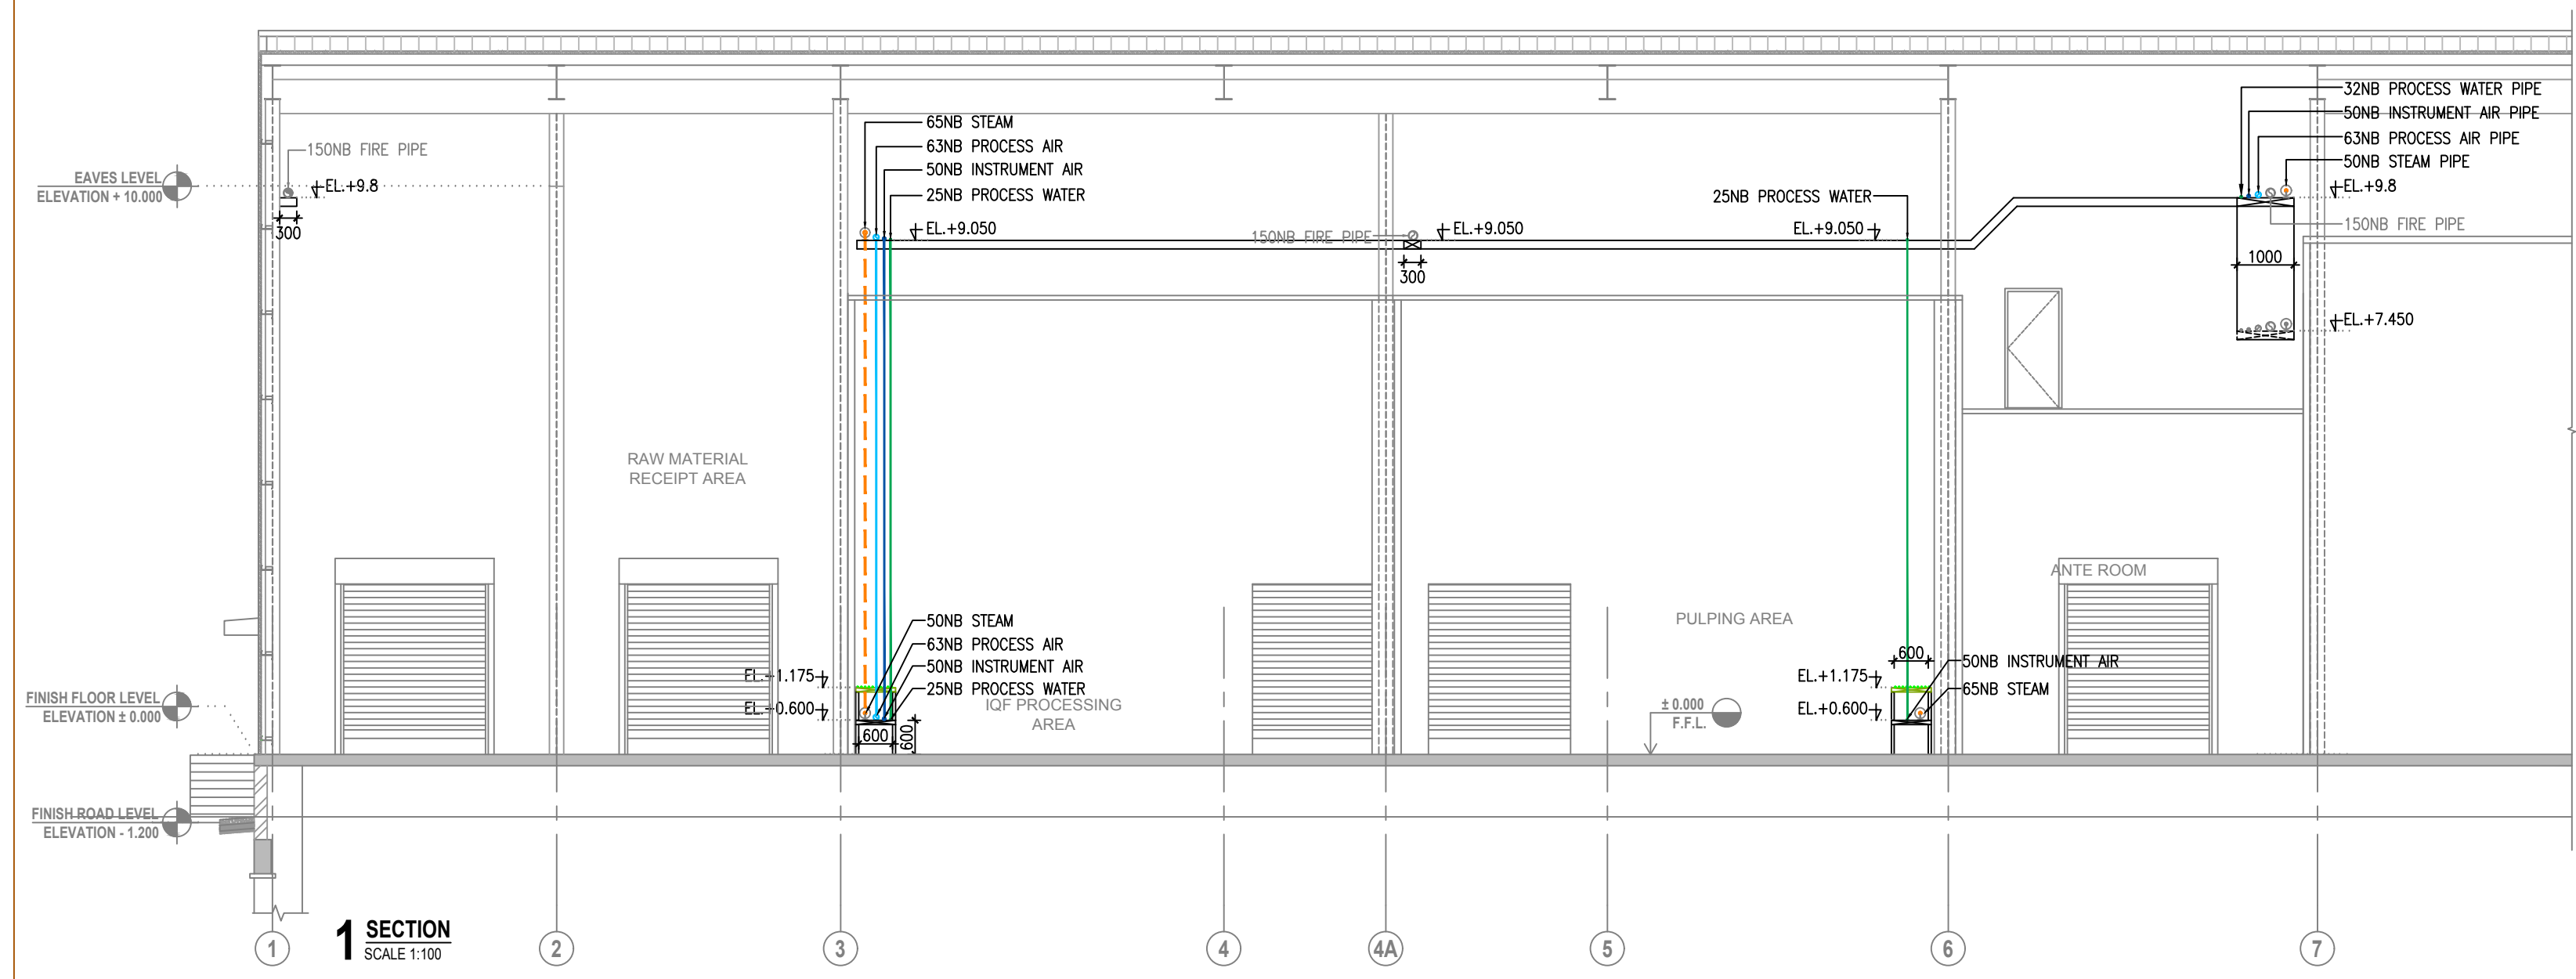

NO.	DATE	DESCRIPTION	DRAWN BY	CHECKED BY
R0	28-05-19	ISSUED FOR TENDER	KRUNAL	MEET

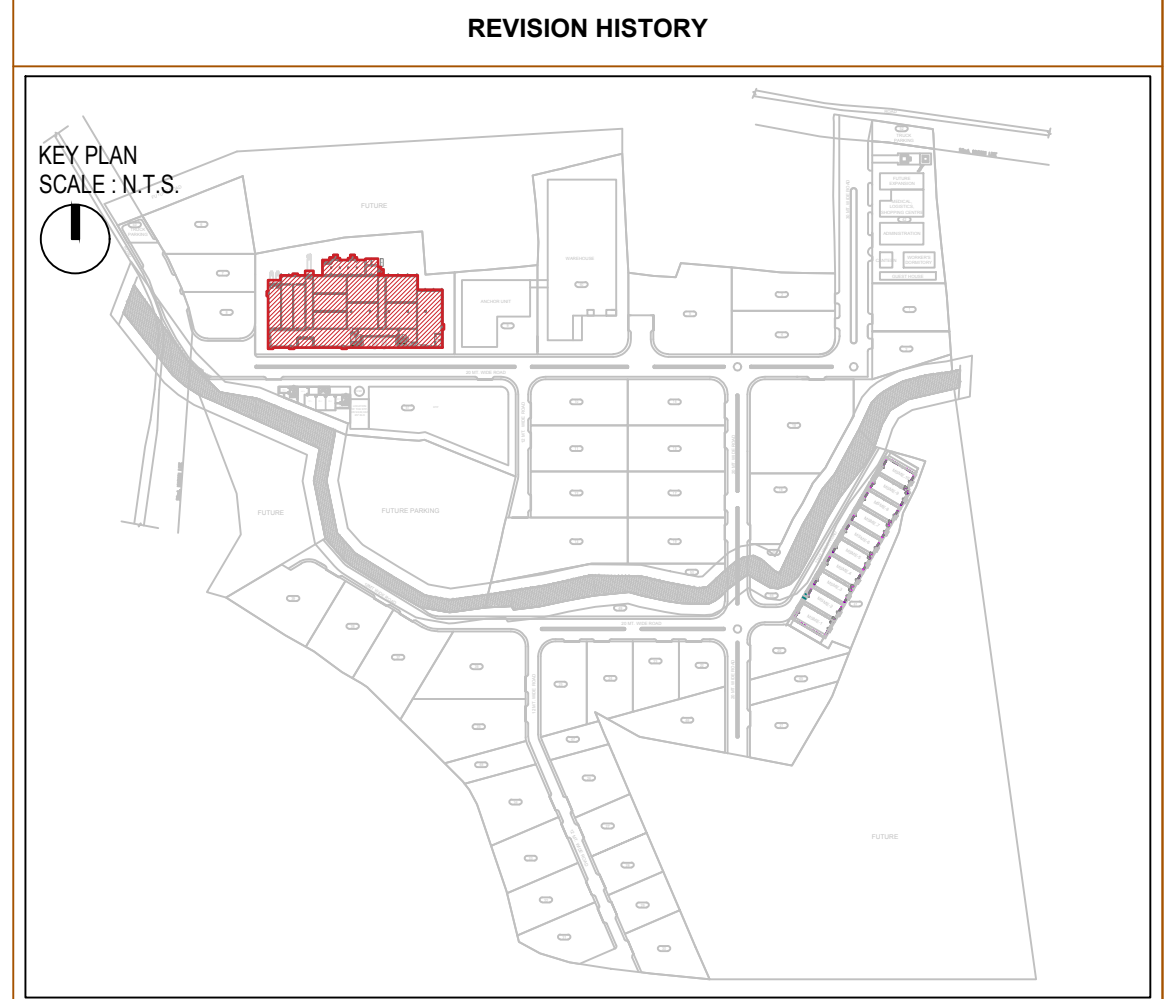

REFERENCE DRAWINGS :

01. ARCHITECTURAL :-	
02. STRUCTURAL :-	
03. HVAC :-	
04. ELECTRICAL :-	
05. UTILITIES :-	

SECTIONS OF PIPING LAYOUT FOR GROUND FLOOR

CP AREA
 PMC
Technopak Advisors Pvt. Ltd.
Gurgaon.

fanidhar
MEGA FOOD PARK – AT MUDARDA, MEHSANA
kheta se bazaar tak

PROJECT NO.	SCALE :	DRAWN :	KRUNAL
2017	1:200	CHECKED:	MEET
DATE :	28-05-2019	APPROVED:	ATUL
		COORDINATION CHECKED:	NITESH

vms ENGINEERING & DESIGN SERVICES (P) LTD.
 CHITRAKOOT FLATS, BEHIND TIMES OF INDIA, OFF ASHRAM ROAD,
 AHMEDABAD-380 009. PHONE: +91 (079) 2658-8234/4488, 40238236
 FAX: +91 (079) 2658 3598 WWW.VMSCONSULTANTS.COM

SHEET SIZE	DRAWING NO.	RELEASED FOR	REVISION:
600x1000	ME.40B.112	T	R0