





THIS DRAWING & DESIGN IS THE SOLE PROPERTY OF VMS & SHALL NOT BE COPIED, TRACED OR REPRODUCED BY ANY MEANS WITHOUT PRIOR WRITTEN CONSENT OF THE FIRM.

GENERAL NOTES :

1. ALL DIMENSIONS ARE IN MM AND LEVELS ARE IN MT, UNLESS OTHERWISE MENTIONED.
2. ALL THE DIMENSIONS SHALL BE READ & NOT TO BE MEASURED.
3. IN CASE OF ANY DISCREPANCY, BRING IT TO THE NOTICE OF THE ARCHITECT IMMEDIATELY.
4. TRAP STATION AT EVERY 30M; TO BE ADDED ON STEAM PIPING.
5. EXPANSION LOOP AT EVERY 30M; TO BE ADDED IN STEAM PIPING.


LEGENDS:

SR.NO.	SYMBOL	DESCRIPTION
01	PR	PRESSURE REDUCING STATION
02	HS	HIGH PRESSURE STEAM
03	MS	MEDIUM PRESSURE STEAM
04	LS	LOW PRESSURE STEAM
05	CR	CONDENSATE RECOVERY
06	PA	PROCESS AIR
07	IA	INSTRUMENT AIR
08	PW	PROCESS WATER
09	RW	RO WATER
10	HP	HOT PIPE
11	BV	BALL VALVE
12	BT	BUTTERFLY VALVE
13	ADT	AUTOMATIC DRAIN TRAP

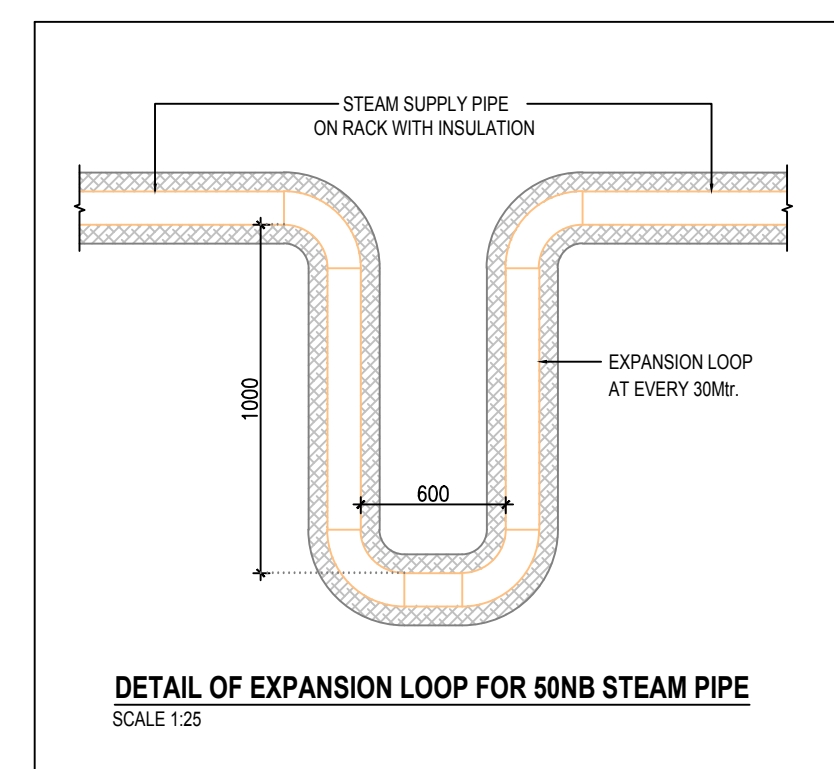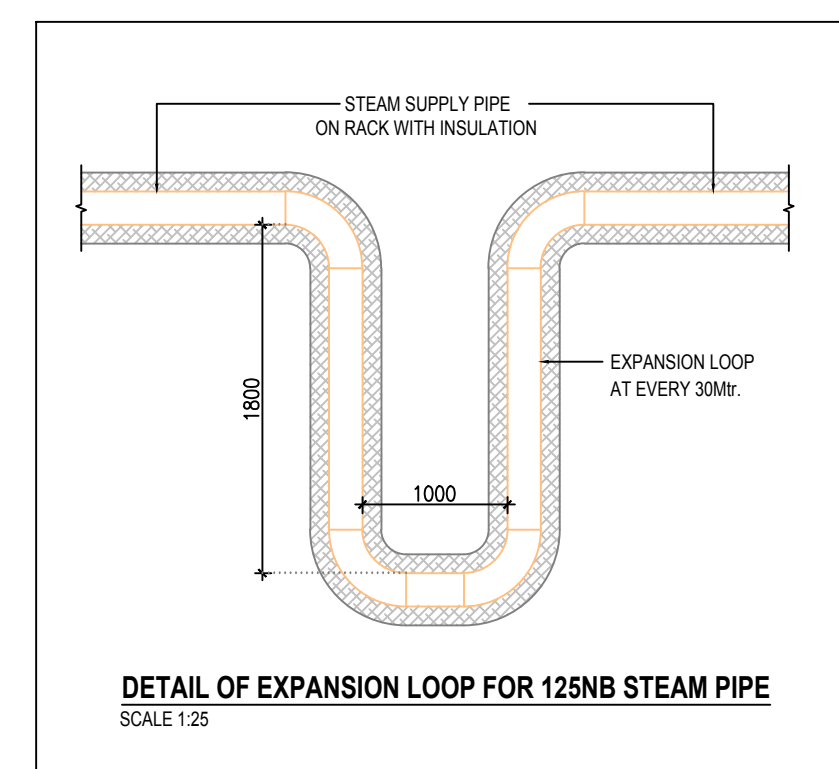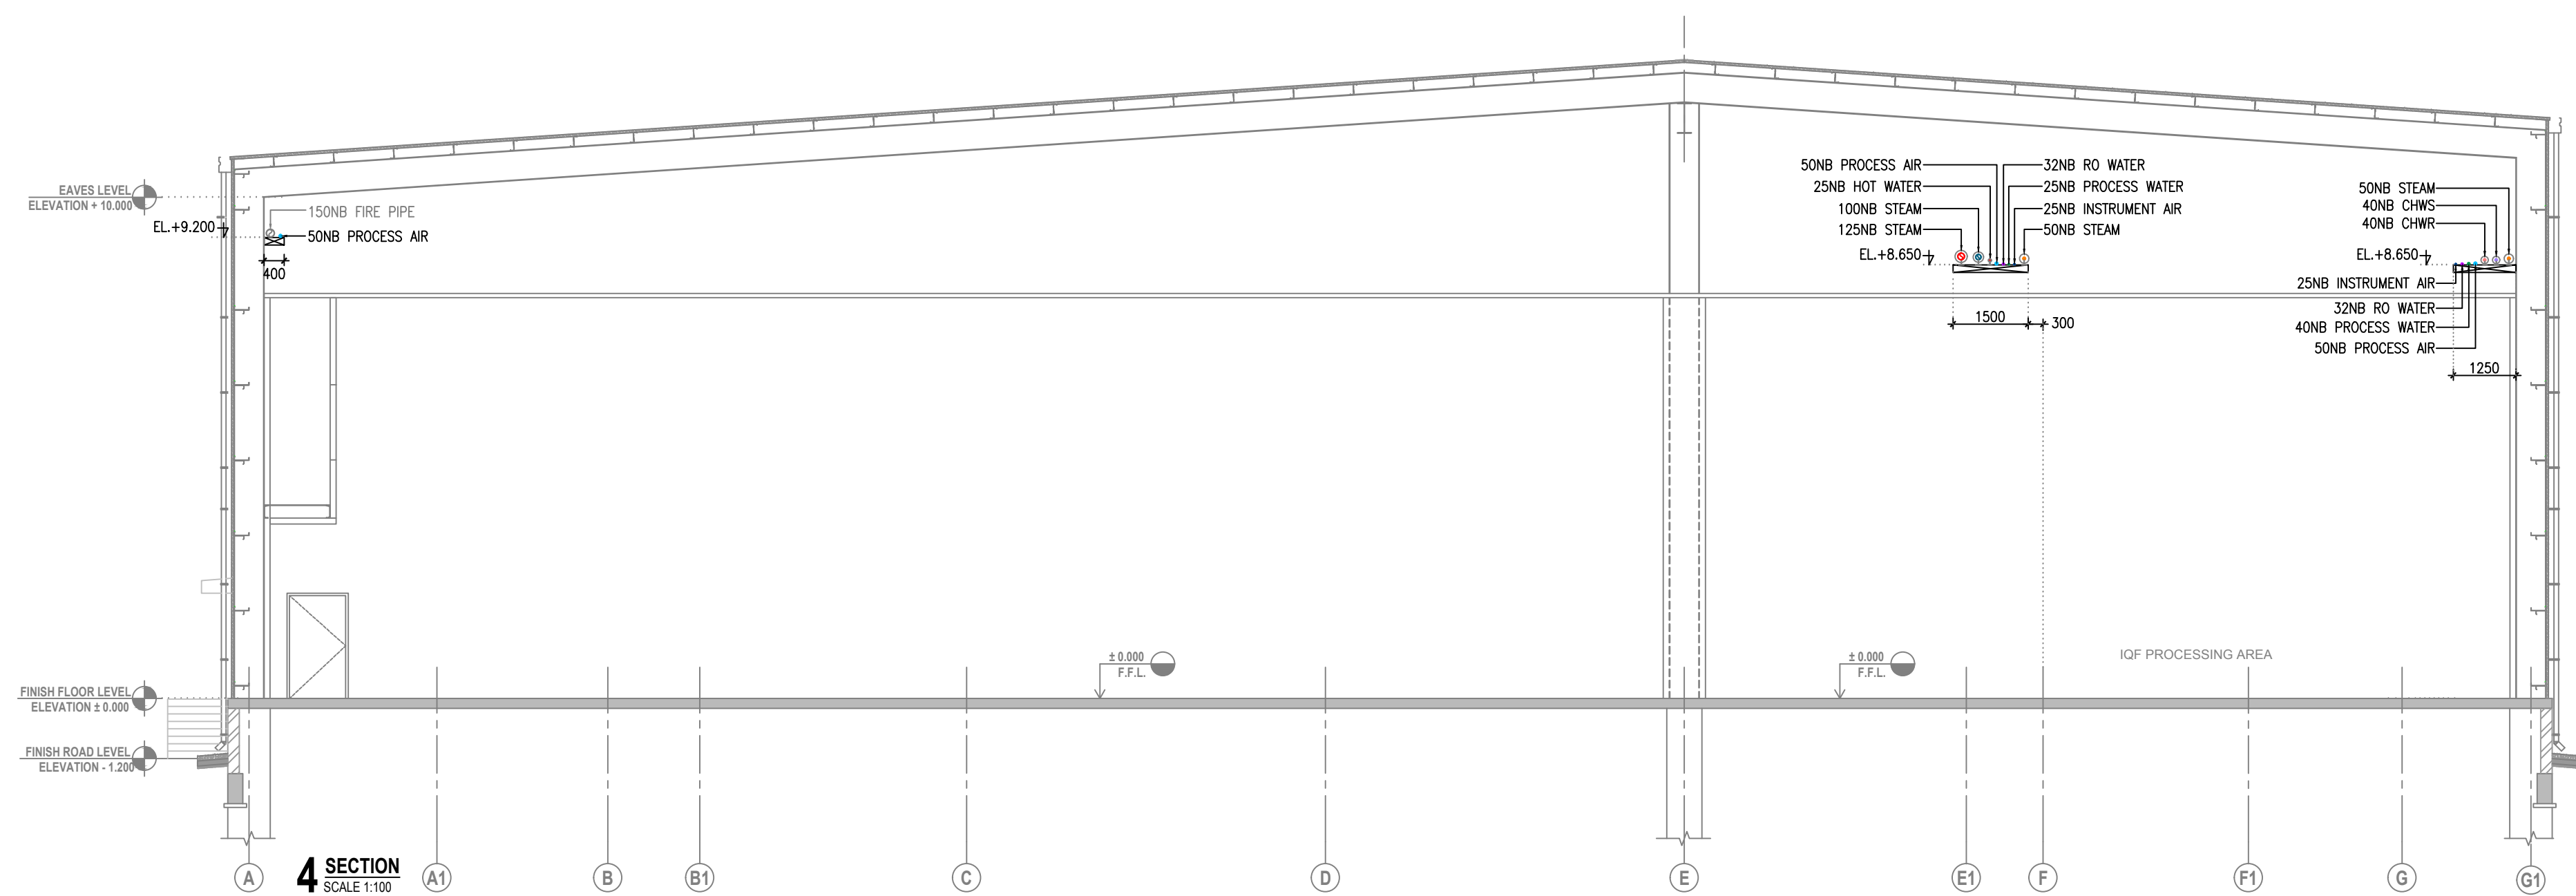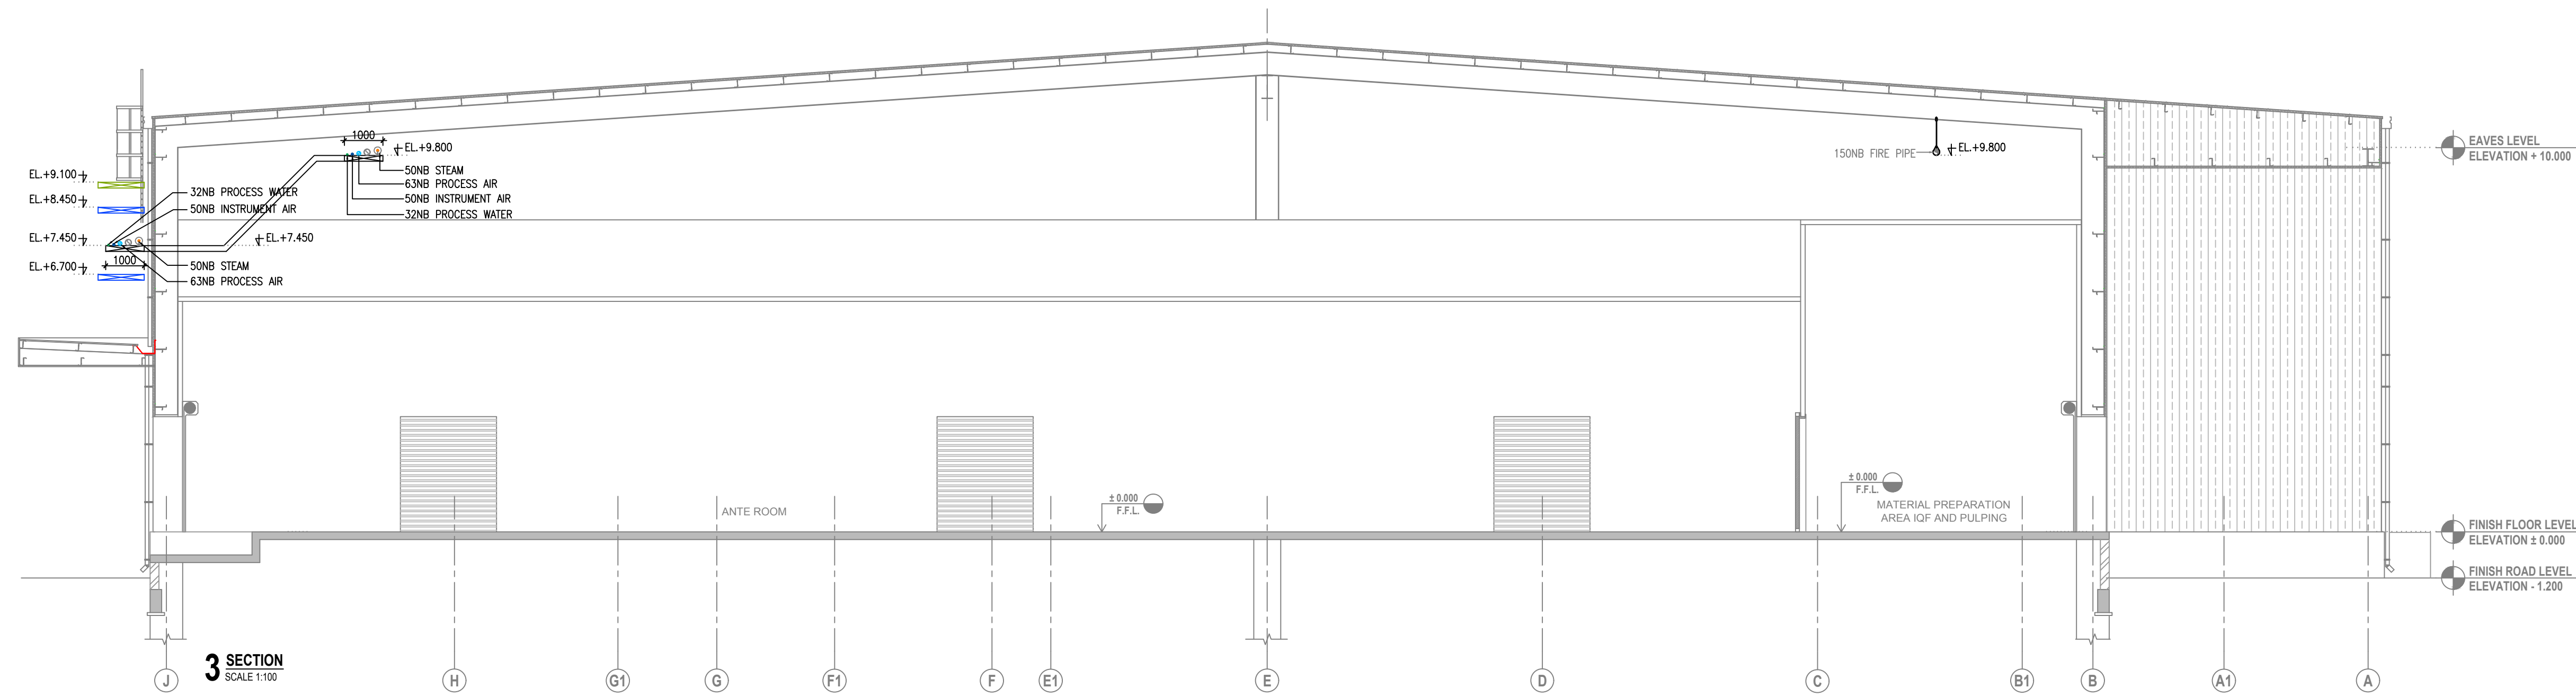

NO.	DATE	DESCRIPTION	DRAWN BY	CHECKED BY
R0	28-05-19	ISSUED FOR TENDER	KRUNAL	MEET

REVISION HISTORY

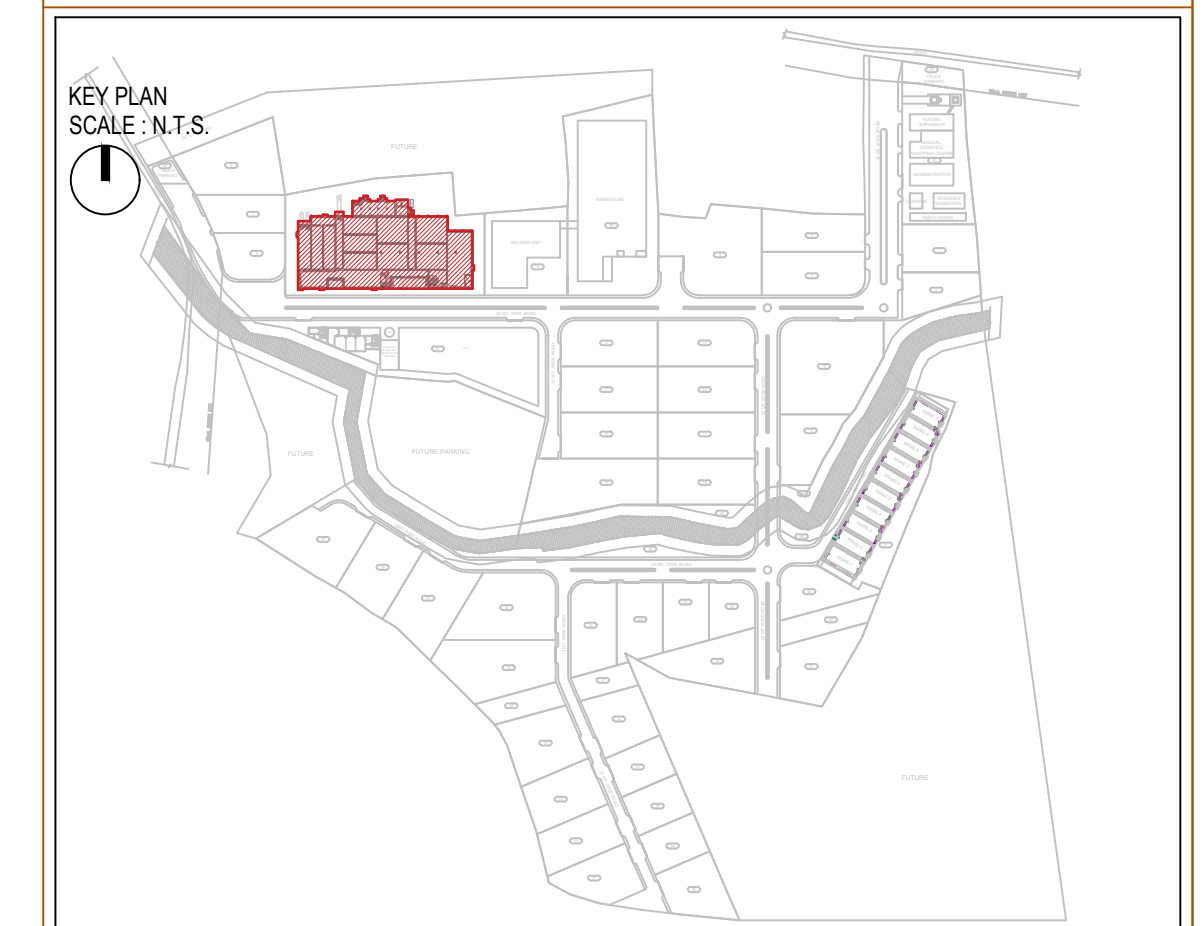

REFERENCE DRAWINGS :

- 01. ARCHITECTURAL :-
- 02. STRUCTURAL :-
- 03. HVAC :-
- 04. ELECTRICAL :-
- 05. UTILITIES :-

SECTIONS OF PIPING LAYOUT FOR GROUND FLOOR

CP AREA

PMC

**Technopak Advisors Pvt. Ltd.**  
**Gurgaon.**

**fanidhar**  
**MEGA FOOD PARK** - AT MUDARDA, MEHSANA  
*kheta se bazaar tak*

PROJECT NO.	SCALE :	DRAWN :	KRUNAL
2017	1:200	CHECKED:	MEET
	DATE :	APPROVED:	ATUL
	28-05-2019	COORDINATION CHECKED:	NITESH

**vms** VMS ENGINEERING & DESIGN SERVICES (P) LTD.  
CHITRAKOOT FLATS, BEHIND TIMES OF INDIA, OFF ASHRAM ROAD,  
AHMEDABAD-380 009. PHONE: +91 (079) 2658-8829/4488, 40238236  
ENGINEERING + ARCHITECTURE FAX: +91 (079) 2658 3598 WWW.VMSCONSULTANTS.COM

SHEET SIZE	DRAWING NO.	RELEASED FOR	REVISION:
600x1000	ME.40B.113	T	R0