


THIS DRAWING & DESIGN IS THE SOLE PROPERTY OF VMS & SHALL NOT BE COPIED, TRACED OR REPRODUCED BY ANY MEANS WITHOUT PRIOR WRITTEN CONSENT OF THE FIRM.


GENERAL NOTES :

1. ALL DIMENSIONS ARE IN MM AND LEVELS ARE IN MM, UNLESS OTHERWISE MENTIONED.
2. ALL THE DIMENSIONS SHALL BE READ & NOT TO BE MEASURED.
3. IN CASE OF ANY DISCREPANCY, BRING IT TO THE NOTICE OF THE ARCHITECT IMMEDIATELY.

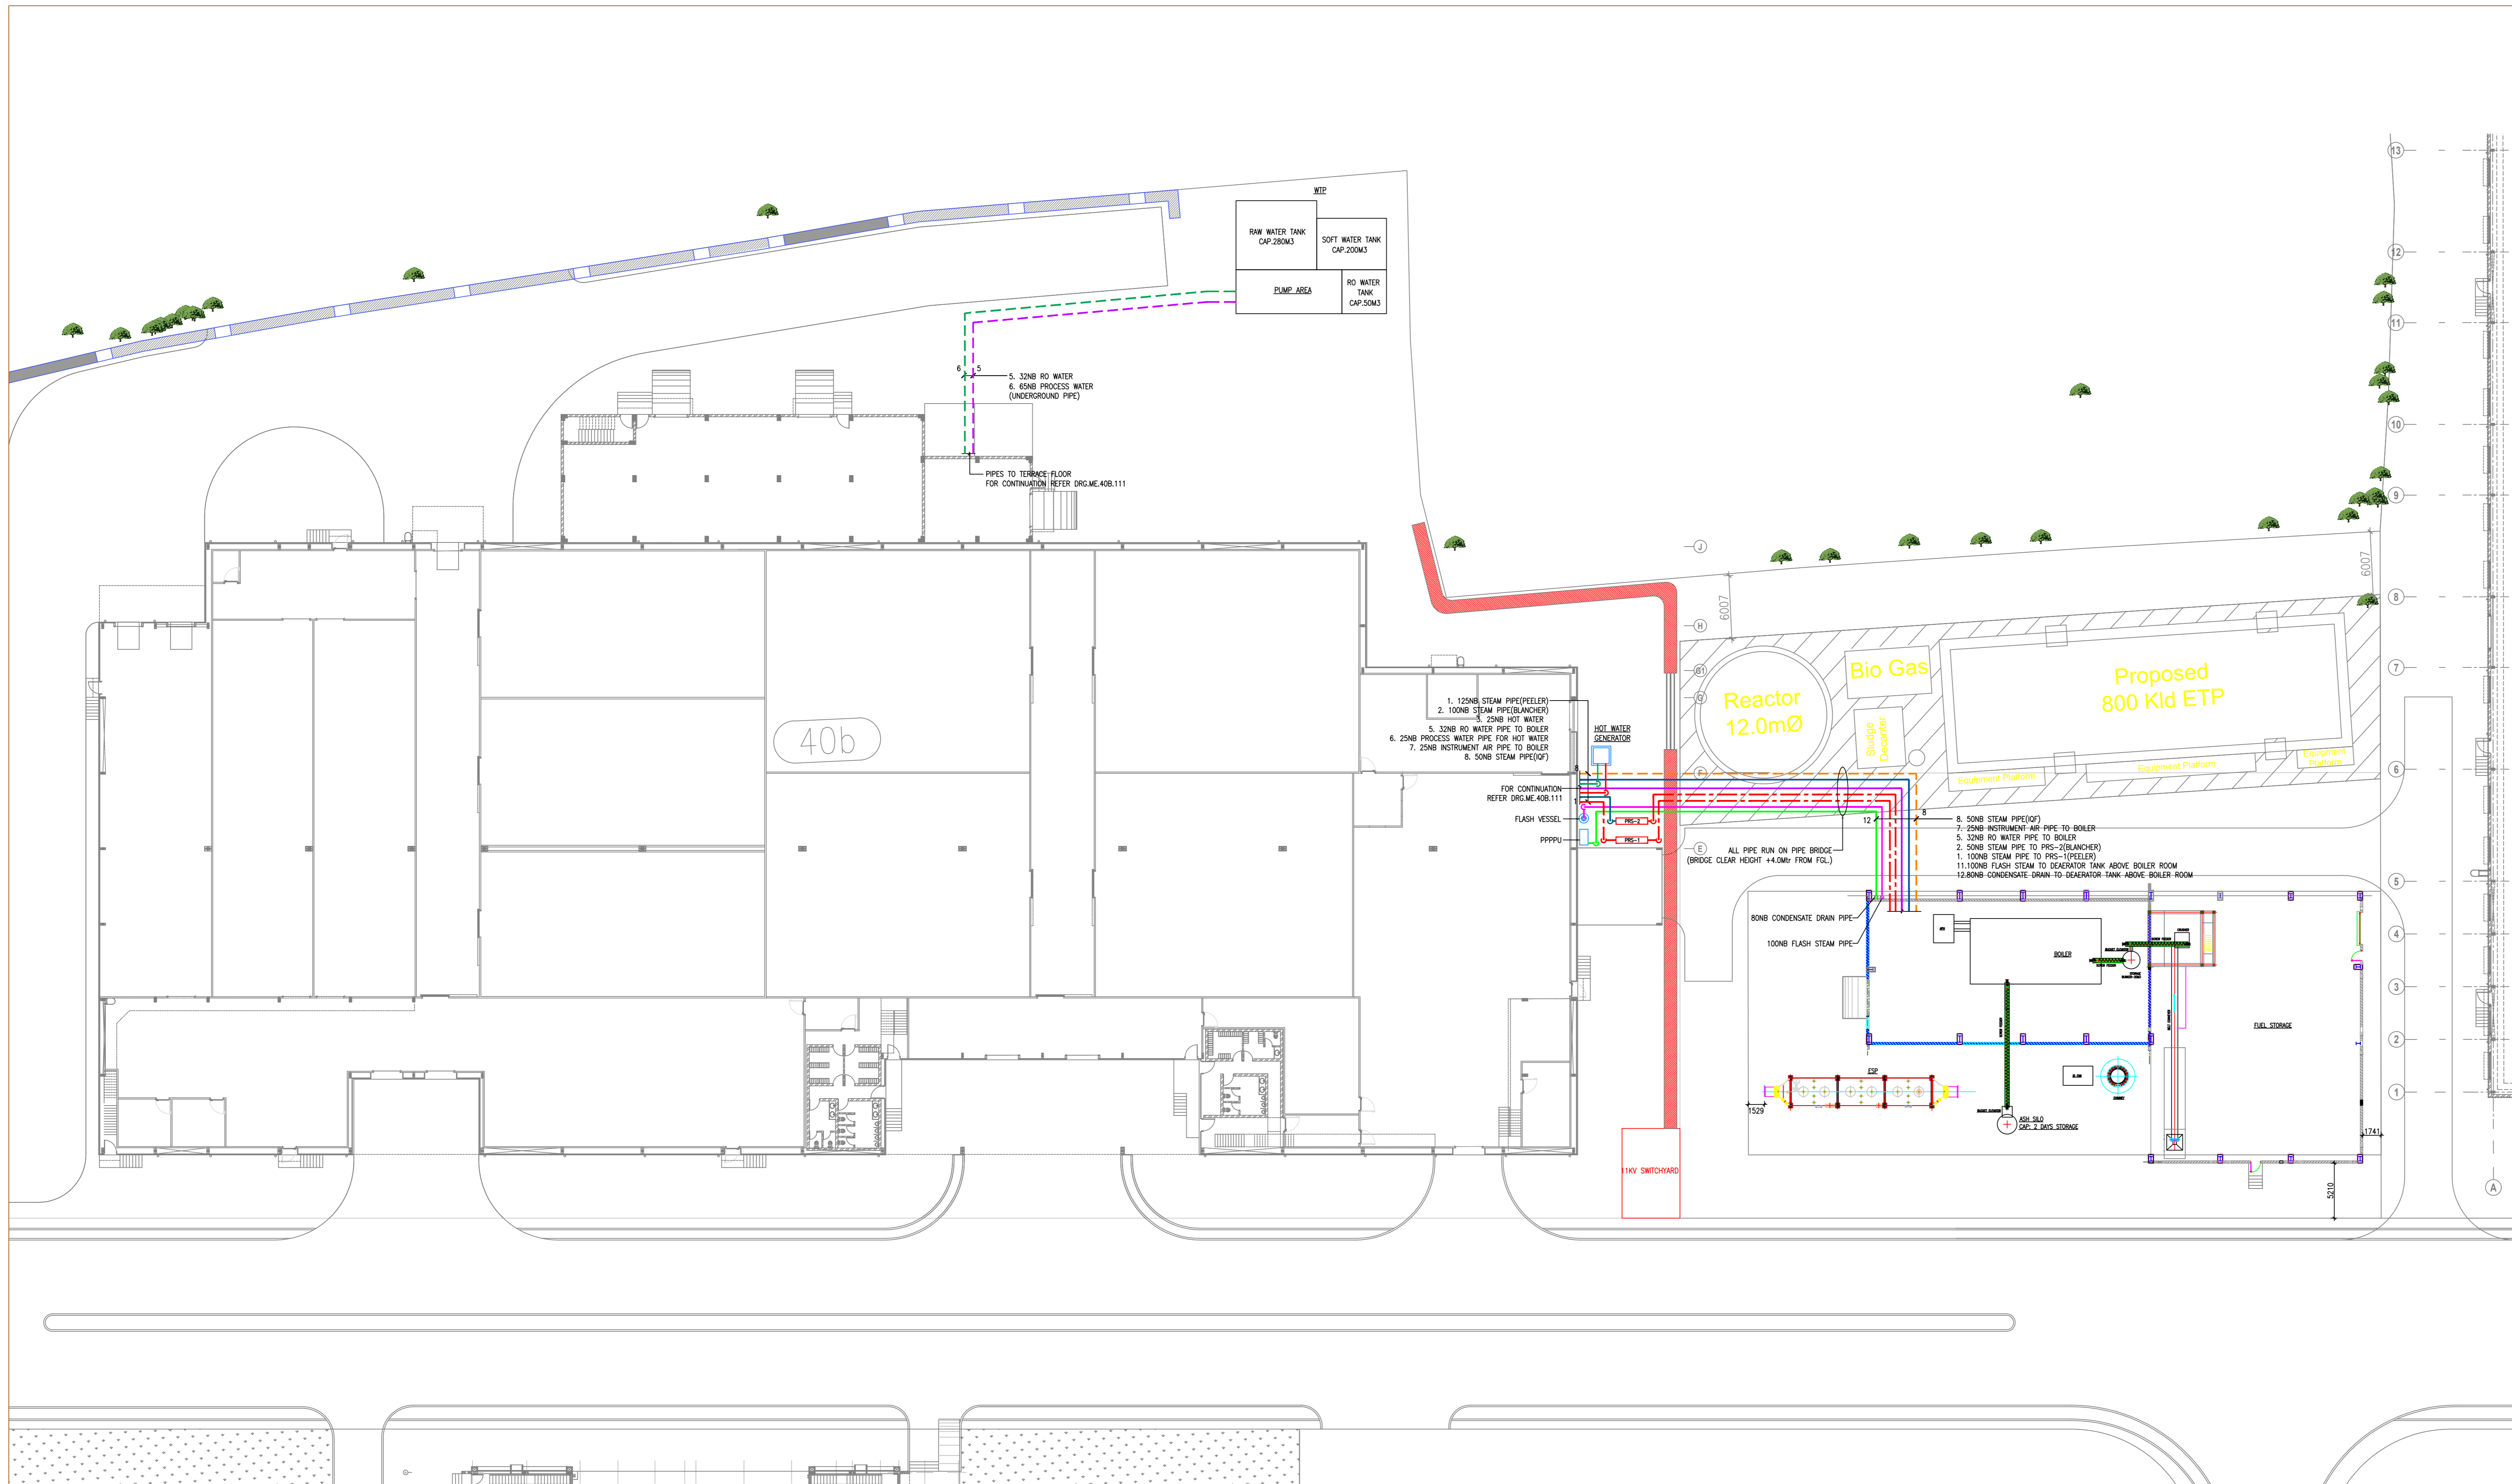

NO.	DATE	DESCRIPTION	DRAWN BY	CHECKED BY
R0	28-05-19	ISSUED FOR TENDER	KRUNAL	MEET

REVISION HISTORY

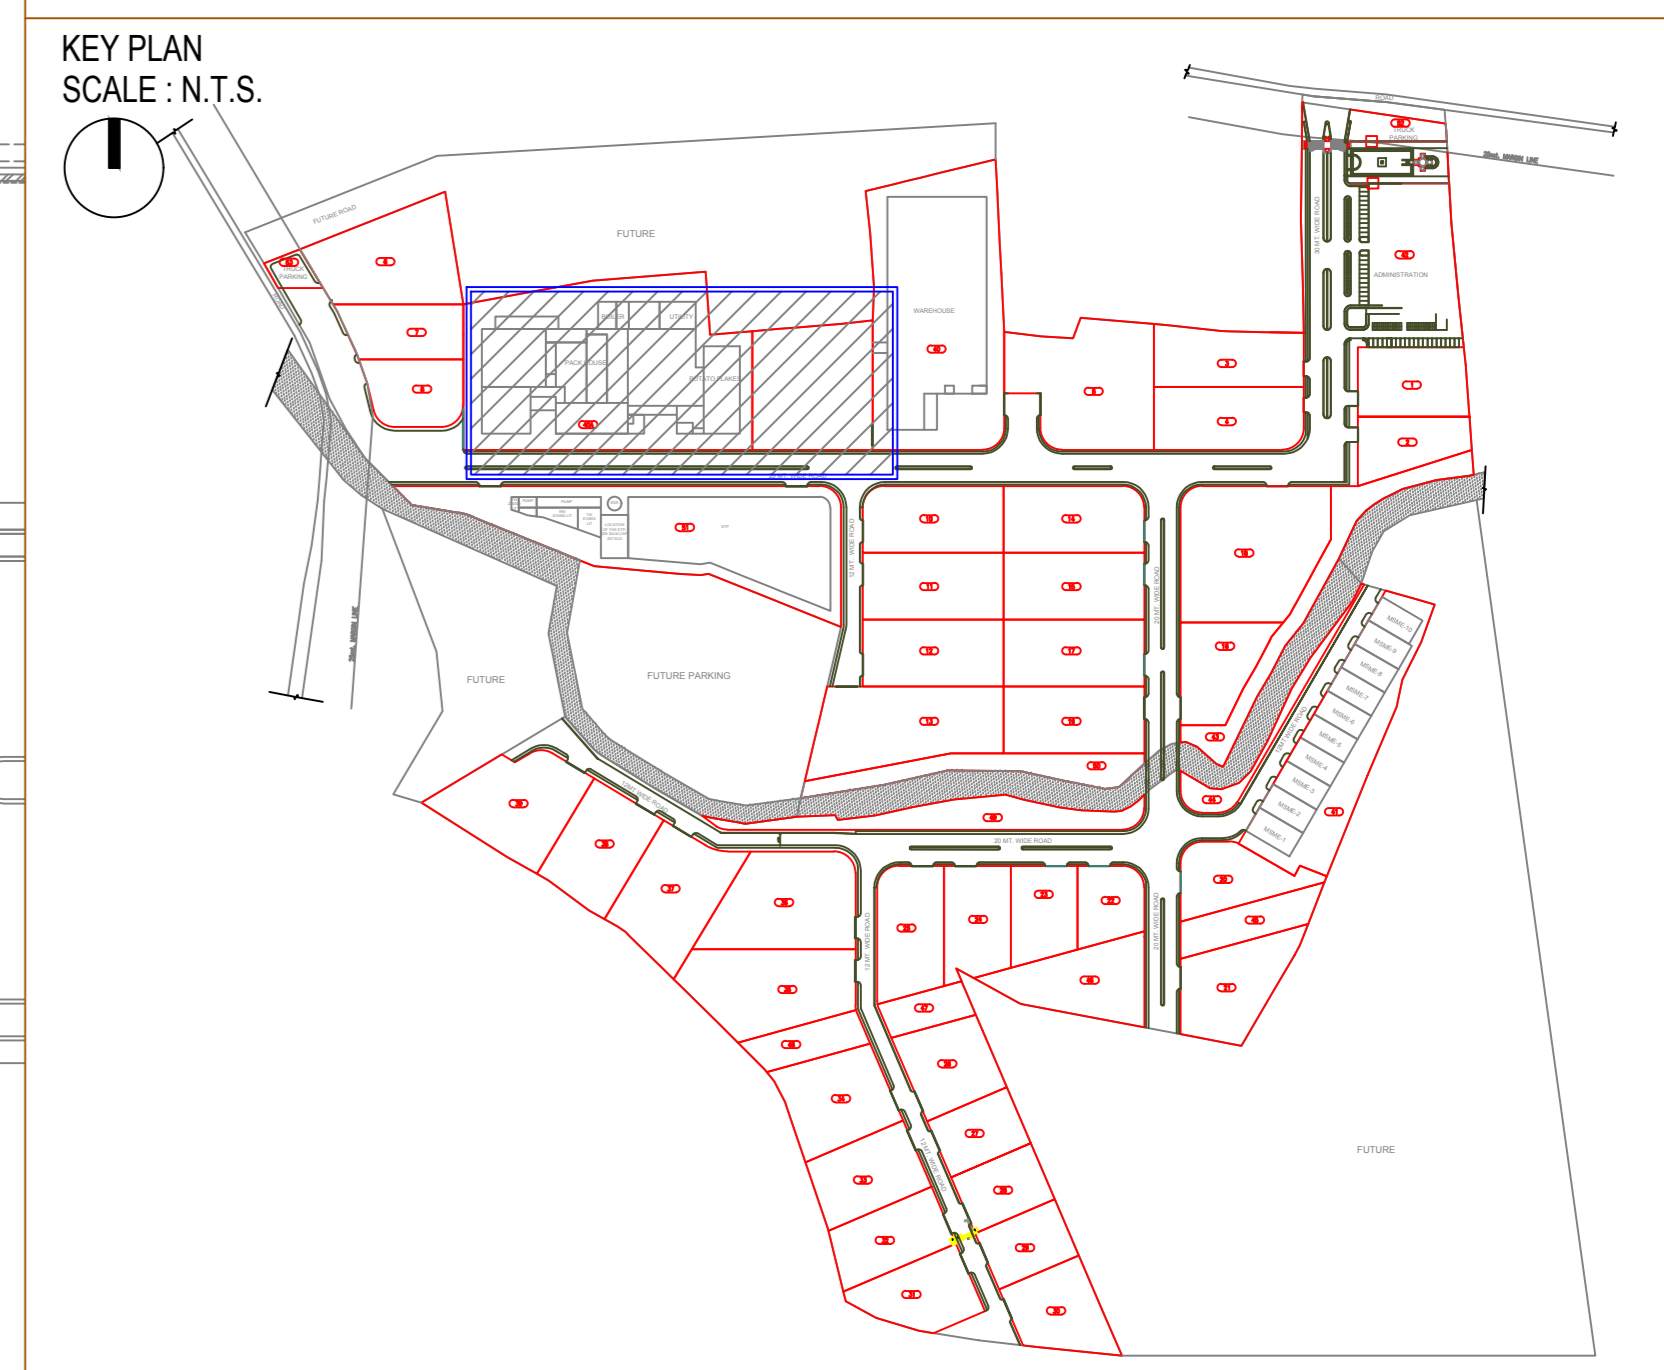

REFERENCE DRAWINGS :

01. ARCHITECTURAL :	
02. STRUCTURAL :	
03. HVAC :	
04. ELECTRICAL :	
05. UTILITIES :	

EXTERNAL UTILITY PIPING LAYOUT

MASTER SITE PLAN

PMC
Technopak Advisors Pvt. Ltd.
Gurgaon.

fanidhar®
MEGA FOOD PARK – AT MUDARDA, MEHSANA
khet se bazaar tak...

PROJECT NO.	SCALE :	DRAWN :
2017	N.T.S.	KRUNAL
	DATE :	CHECKED :
	28-05-2019	MEET
		APPROVED :
		ATUL
		COORDINATION CHECKED :
		NITESH

vms ENGINEERING & DESIGN SERVICES (P) LTD.
 CHITRAKOOT FLATS, BEHIND TIMES OF INDIA, OFF ASHRAM ROAD,
 AHMEDABAD-380 009. PHONE: +91 (079) 2658-8204/4488, 40228235
 FAX: +91 (079) 2658 3596 WWW.VMSCONSULTANTS.COM

SHEET SIZE	DRAWING NO.	RELEASED FOR	REVISION:
A0	ME.G.111	T	R0