

THIS DRAWING & DESIGN IS THE SOLE PROPERTY OF VMS & SHALL NOT BE COPIED, TRACED OR REPRODUCED BY ANY MEANS WITHOUT PRIOR WRITTEN CONSENT OF THE FIRM.

GENERAL NOTES :


1. ALL DIMENSIONS ARE IN MM AND LEVELS ARE IN MT, UNLESS OTHERWISE MENTIONED.
2. ALL THE DIMENSIONS SHALL BE READ & NOT TO BE MEASURED.
3. IN CASE OF ANY DISCREPANCY, BRING IT TO THE NOTICE OF THE ARCHITECT IMMEDIATELY.

LEGENDS

SYMBOL	SYMBOL	LEGN	DESCRIPTION
—	—	—	OVERHEAD FIRE HYDRANT PIPE
—	—	—	INTERNAL HYDRANT PIPE HOSE REEL & HOSE BOX
—	—	—	INTERNAL HYDRANT
—	—	—	INTERNAL HOSE BOX
—	—	—	15MM RUBBER HOSE
—	—	—	HOSE REEL
—	—	—	SCREWED BALL VALVE
—	—	—	BUTTERFLY VALVE
—	—	—	AIR RELEASE VALVE

NO.	DATE	DESCRIPTION	DRAWN BY	CHECKED BY
RD	03-06-19	ISSUED FOR TENDER	KRUNAL	VIGNESH

REVISION HISTORY

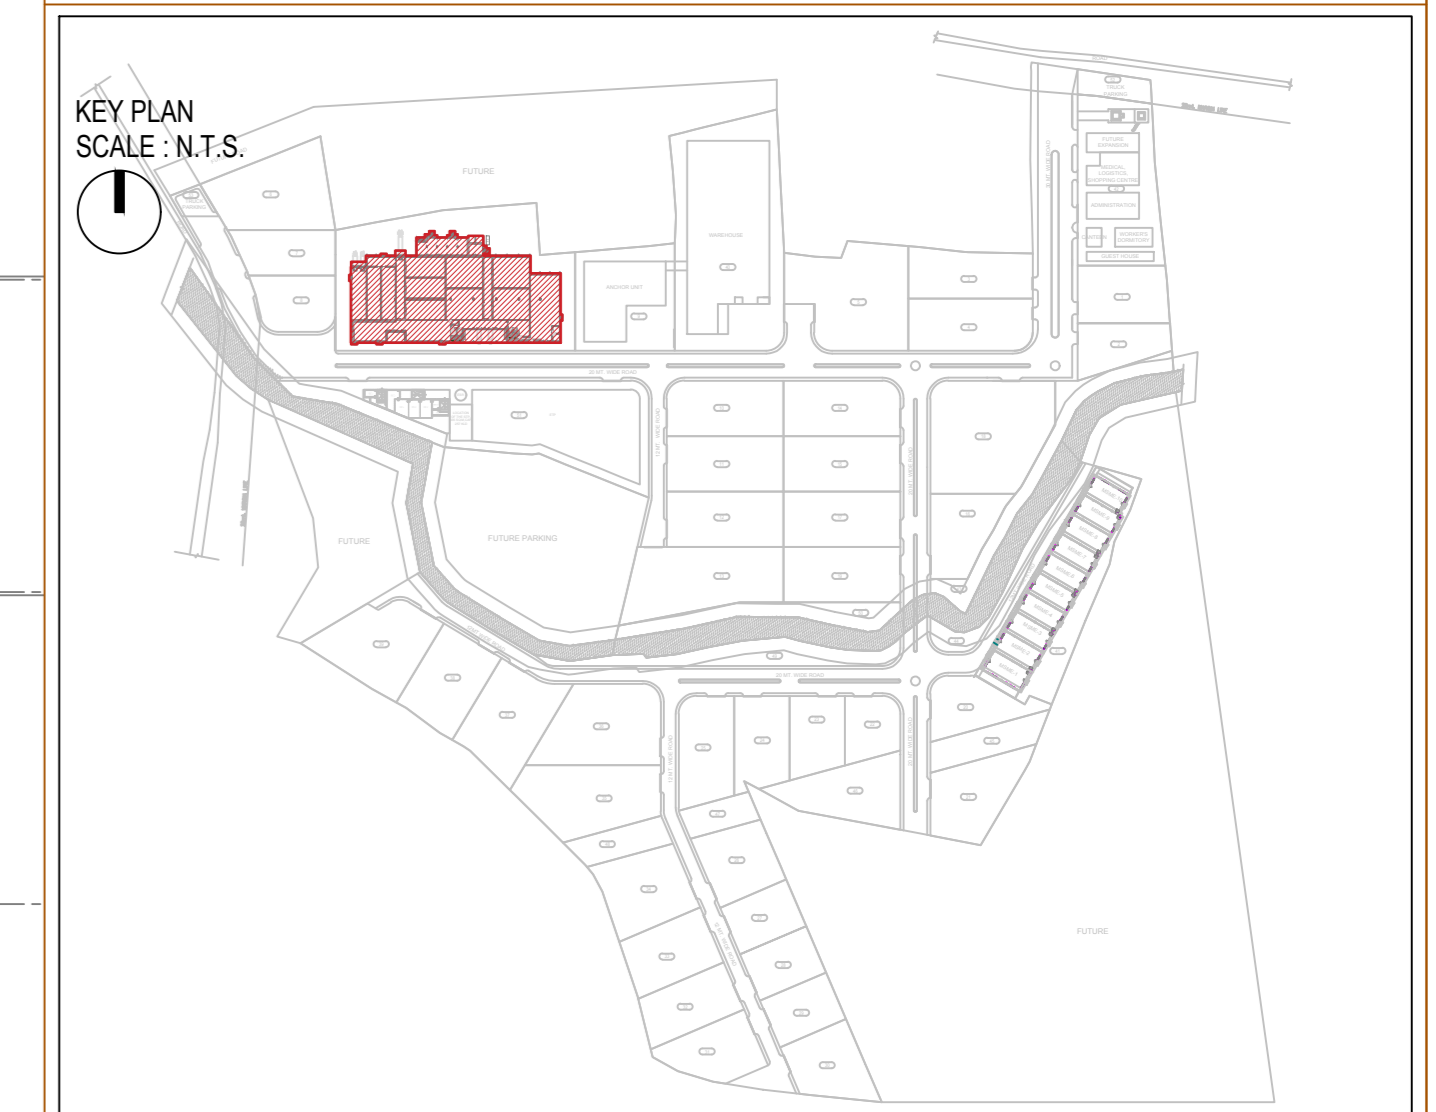

REFERENCE DRAWINGS :

- 01. ARCHITECTURAL : -
- 02. STRUCTURAL : -
- 03. HVAC : -
- 04. ELECTRICAL : -
- 05. UTILITIES : -

INTERNAL HYDRANT LAYOUT FOR GROUND FLOOR

CP AREA


PMC
Technopak Advisors Pvt. Ltd.
Gurgaon.

fanidhar
MEGA FOOD PARK - AT MUDARDA, MEHSANA
kheta se bazaar tak...

PROJECT NO:	SCALE :	DRAWN :	KRUNAL
2017	1:200	CHECKED :	VIGNESH
DATE :	03-06-2019	APPROVED :	NANCY
		COORDINATION CHECKED :	NITESH

vms VMS ENGINEERING & DESIGN SERVICES (P) LTD.
 CHITRAKOOT FLATS, BEHIND TIMES OF INDIA OFF ASHRAM ROAD,
 AHMEDABAD-380 009. PHONE: +91 (079) 2658 8028/8488. #5292318
 ENGINEERING + ARCHITECTURE FAX: +91 (079) 2658 3596 WWW.VMSCONSULTANTS.COM

SHEET SIZE	DRAWING NO.	RELEASED FOR	REVISION
600x1000	MF.40B.302	T	R0

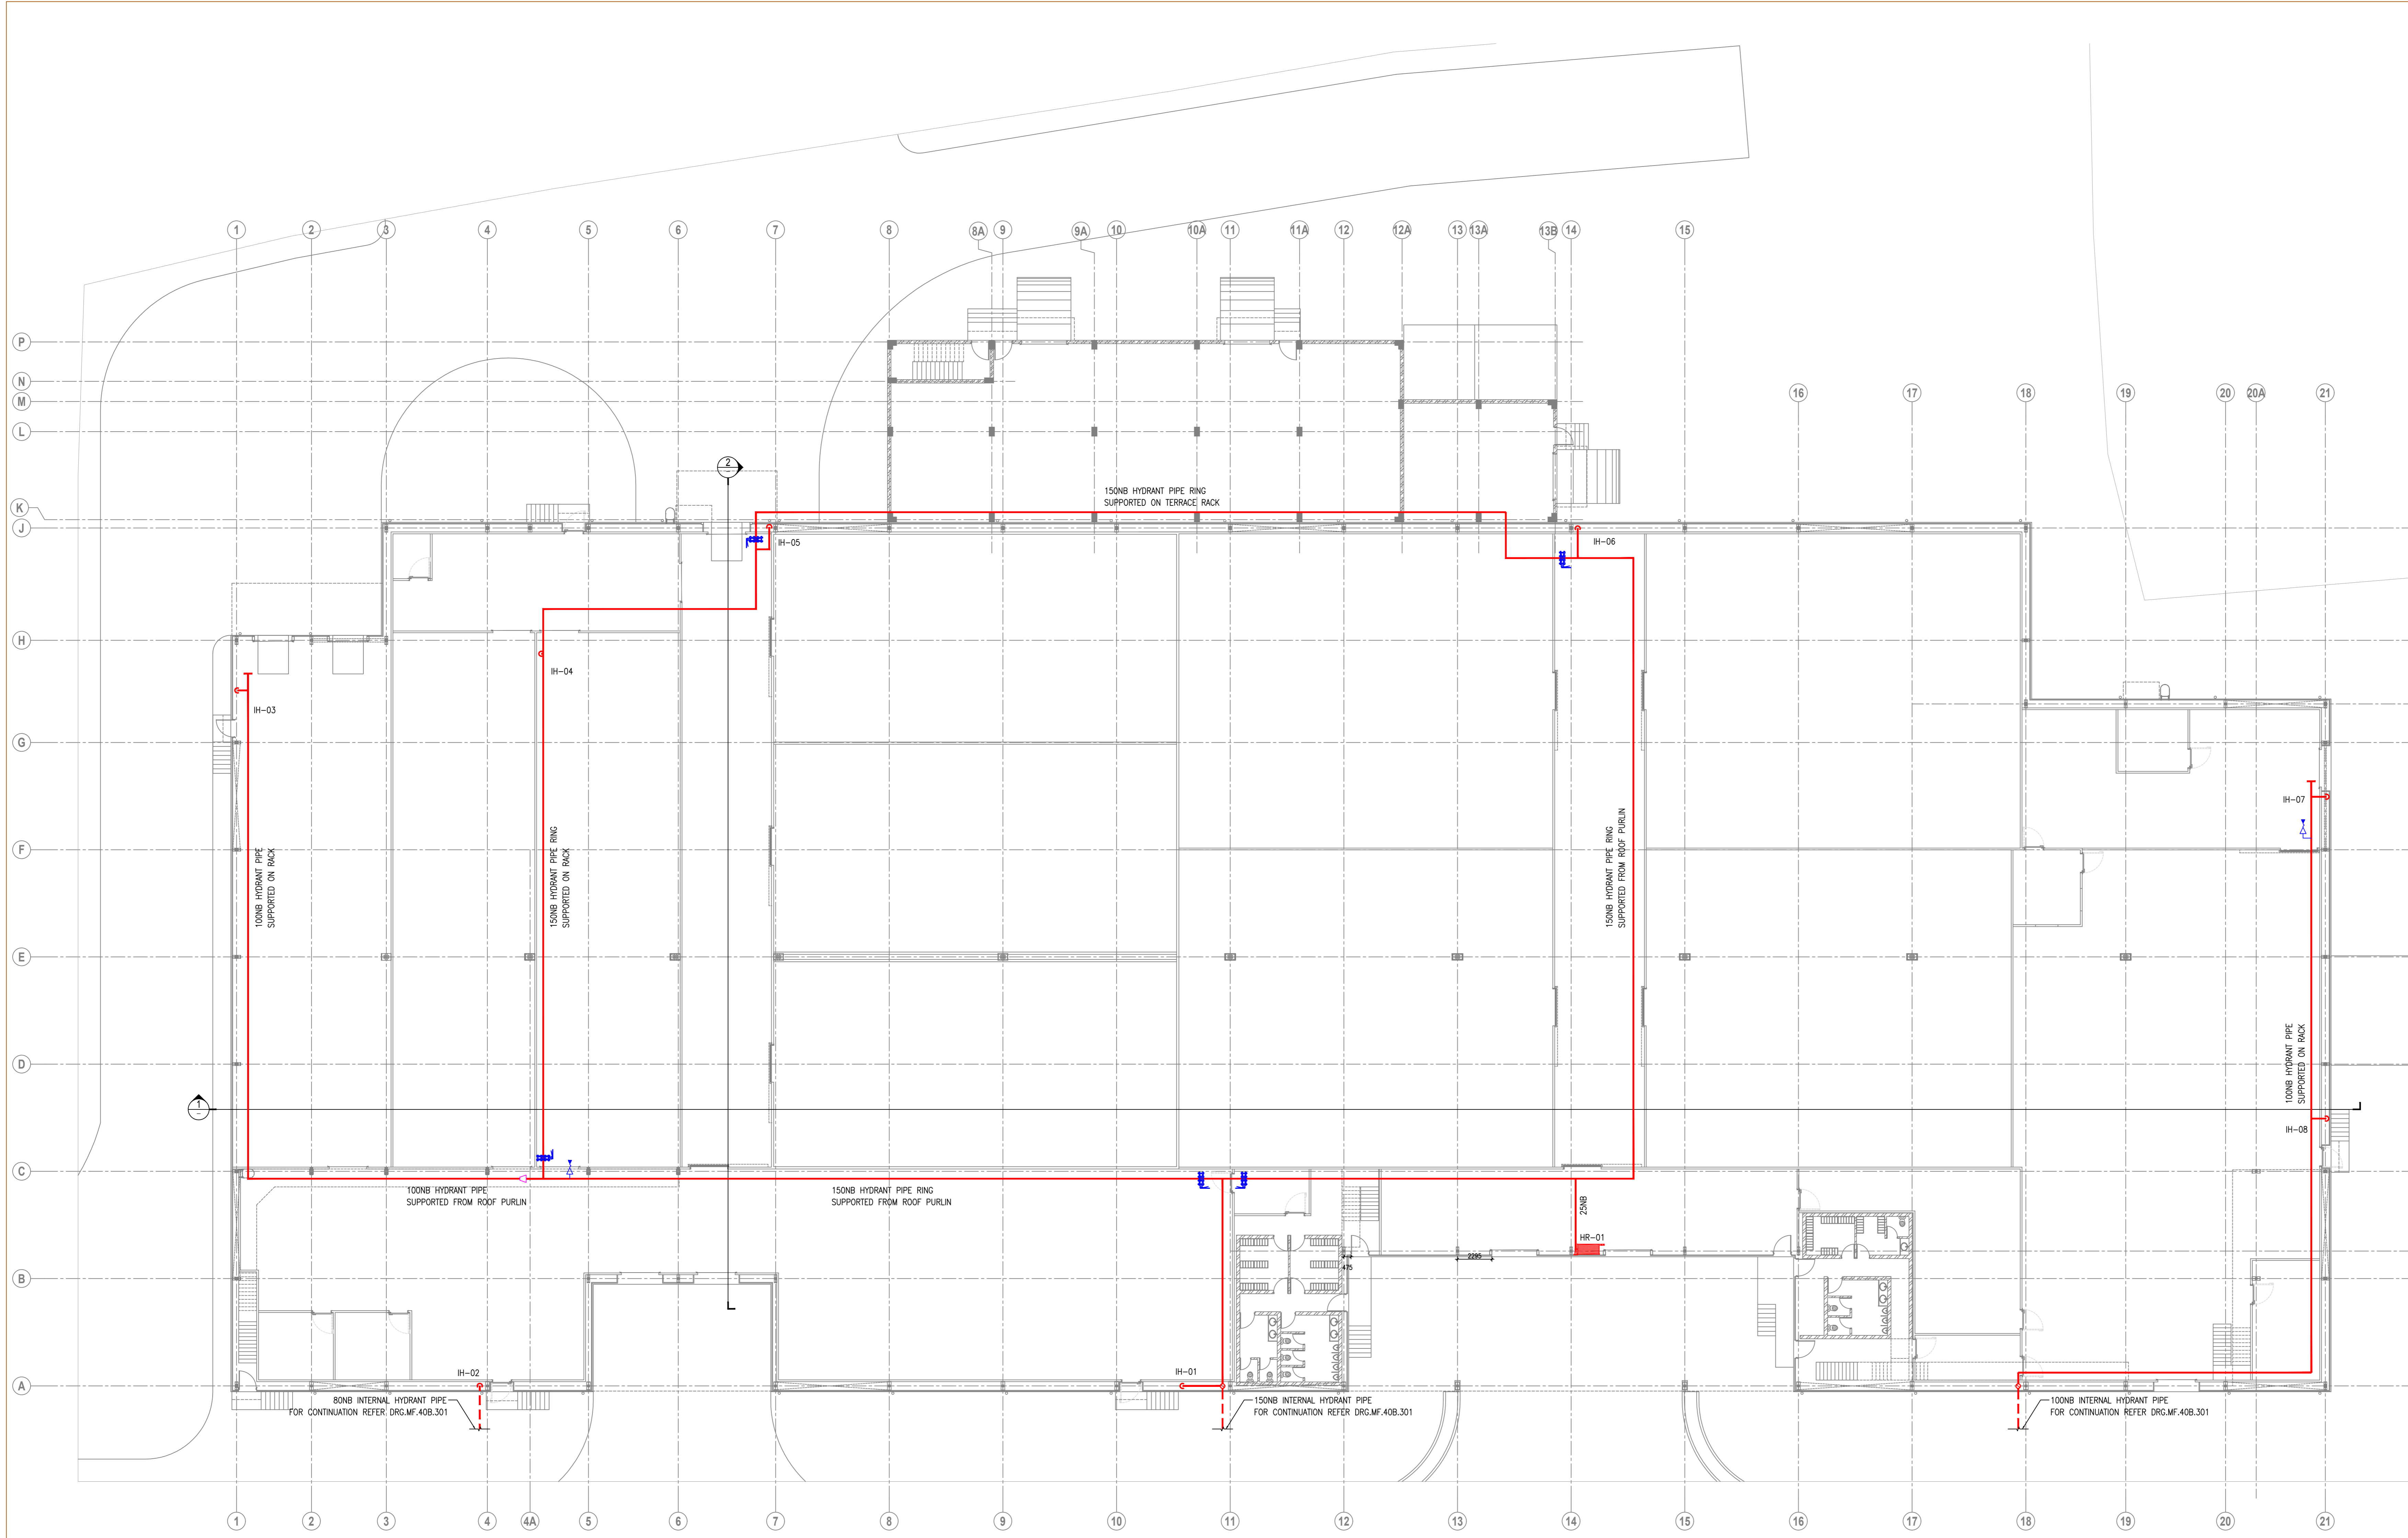

A GROUND FLOOR PLAN
 SCALE 1:200