


THIS DRAWING & DESIGN IS THE SOLE PROPERTY OF VMS & SHALL NOT BE COPIED, TRACED OR REPRODUCED BY ANY MEANS WITHOUT PRIOR WRITTEN CONSENT OF THE FIRM.

**GENERAL NOTES :**

1. ALL DIMENSIONS ARE IN MM AND LEVELS ARE IN MT, UNLESS OTHERWISE MENTIONED.
2. ALL THE DIMENSIONS SHALL BE READ & NOT TO BE MEASURED.
3. IN CASE OF ANY DISCREPANCY, BRING IT TO THE NOTICE OF THE ARCHITECT IMMEDIATELY.


**LEGEND :**

Sr.No.	SYMBOL	DESCRIPTION
1		4.5kg CO2 EXTINGUISHER
2		6kg ABC EXTINGUISHER
3		MANUAL CALL POINT
4		HOOTER
5		MULTI DETECTOR
6		MAN FIRE ALARM PANEL

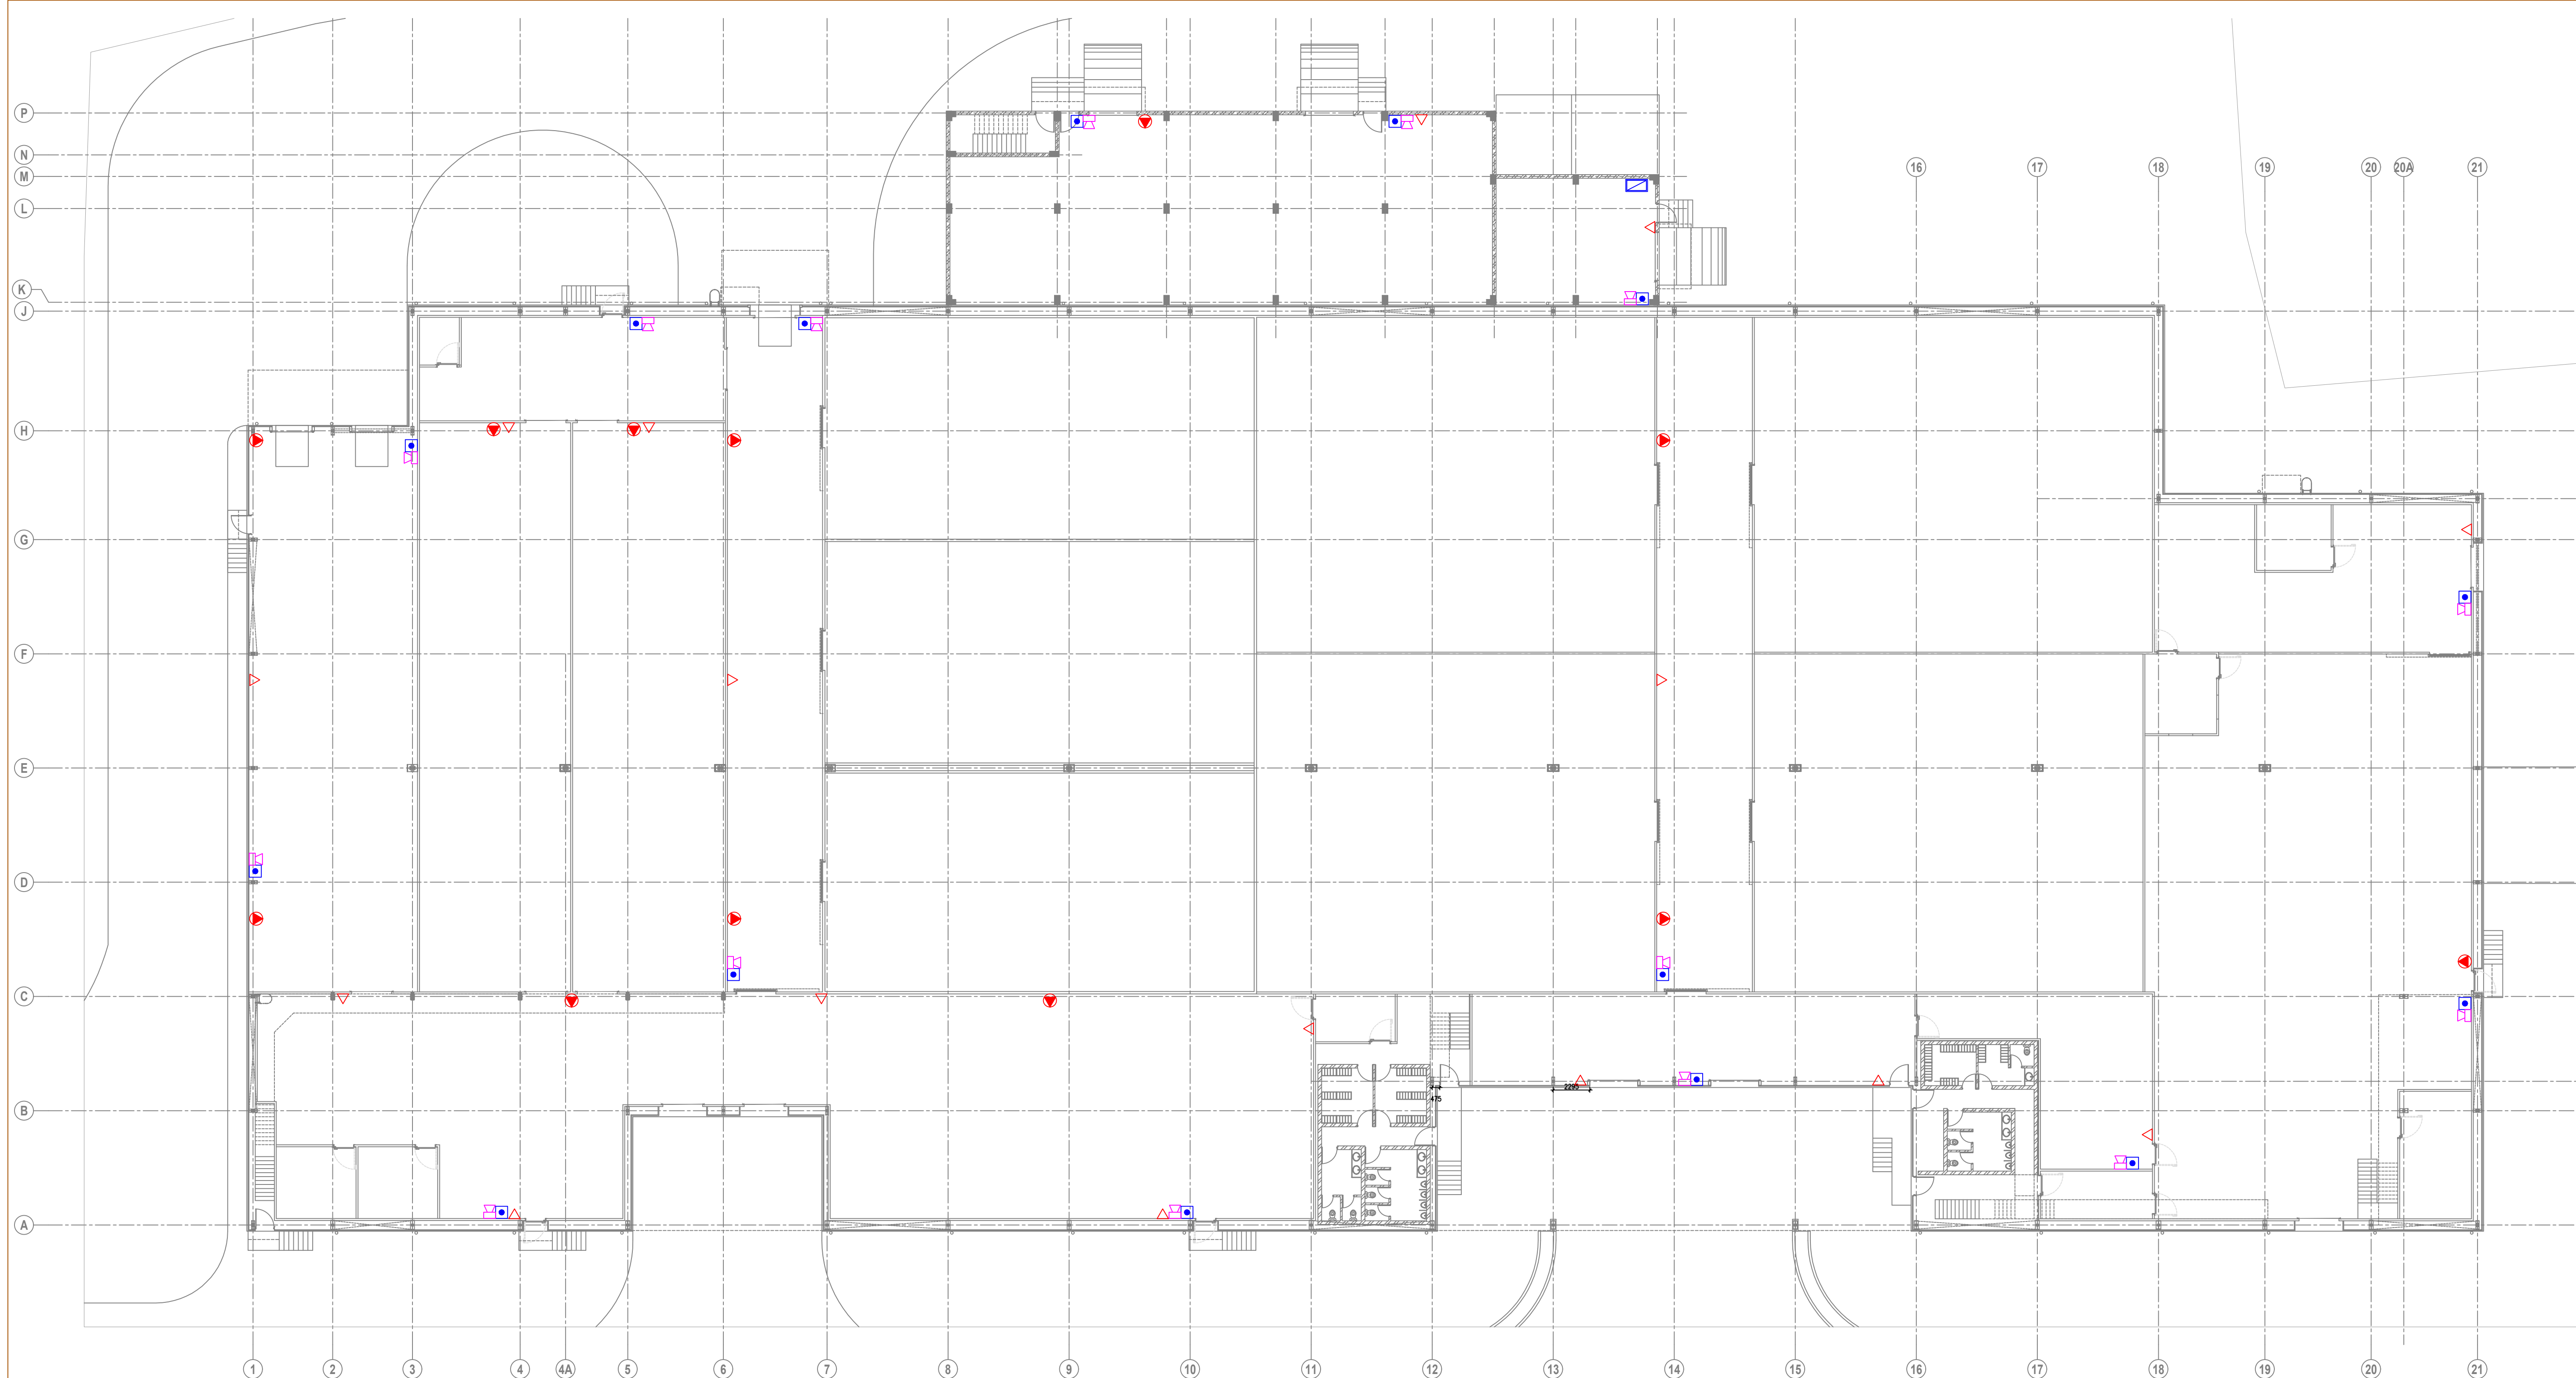

NO.	DATE	DESCRIPTION	DRAWN BY	CHECKED BY
R0	03-06-19	ISSUED FOR TENDER	KRUNAL	VIGNESH

**REVISION HISTORY**

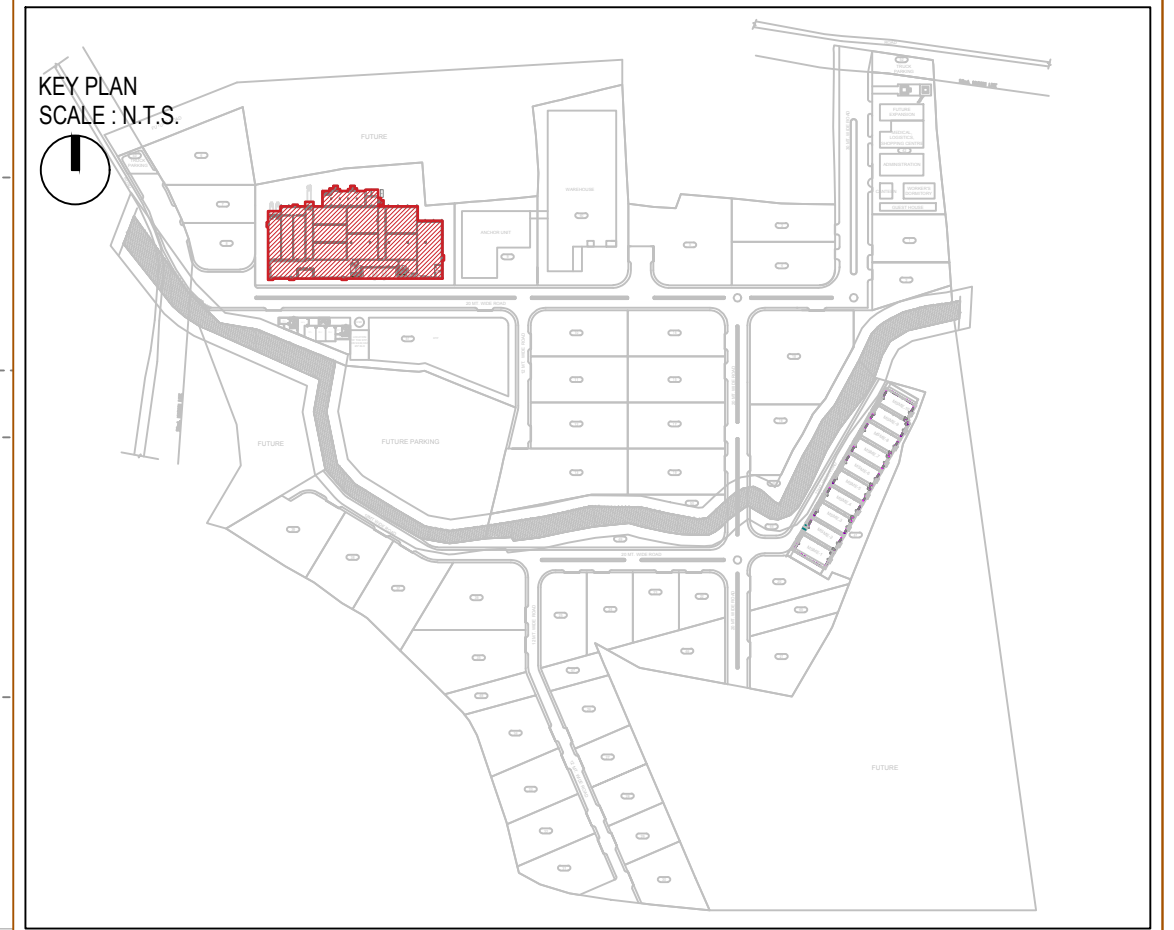

**REFERENCE DRAWINGS :**

01. ARCHITECTURAL :-	
02. STRUCTURAL :-	
03. HVAC :-	
04. ELECTRICAL :-	
05. UTILITIES :-	

**EXTINGUISHER & FAD LAYOUT FOR GROUND & MEZZANINE FLOOR**

**CP AREA**






PMC  
**Technopak Advisors Pvt. Ltd. Gurgaon.**  
**fanidhar**  
**MEGA FOOD PARK - AT MUDARDA, MEHSANA**  
*khut so bekaar tal...*

PROJECT NO.	SCALE :	DRAWN :	KRUNAL
2017	AS NOTED	CHECKED :	VIGNESH
	DATE :	APPROVED :	NANCY
	03-06-2019	COORDINATION CHECKED :	NITESH

**vms** VMS ENGINEERING & DESIGN SERVICES (P) LTD.  
 CHITRAKOOT FLATS, BEHIND TIMES OF INDIA, OFF ASHRAM ROAD, AHMEDABAD-380 009. PHONE: +91 (079) 2658-8239/4488, 40238236  
 ENGINEERING + ARCHITECTURE FAX: +91 (079) 2658 3598 WWW.VMSCONSULTANTS.COM

SHEET SIZE	DRAWING NO.	RELEASED FOR	REVISION:
<b>600x1000</b>	<b>MF.40B.321</b>	<b>T</b>	<b>R0</b>

**A GROUND FLOOR PLAN**  
SCALE 1:200

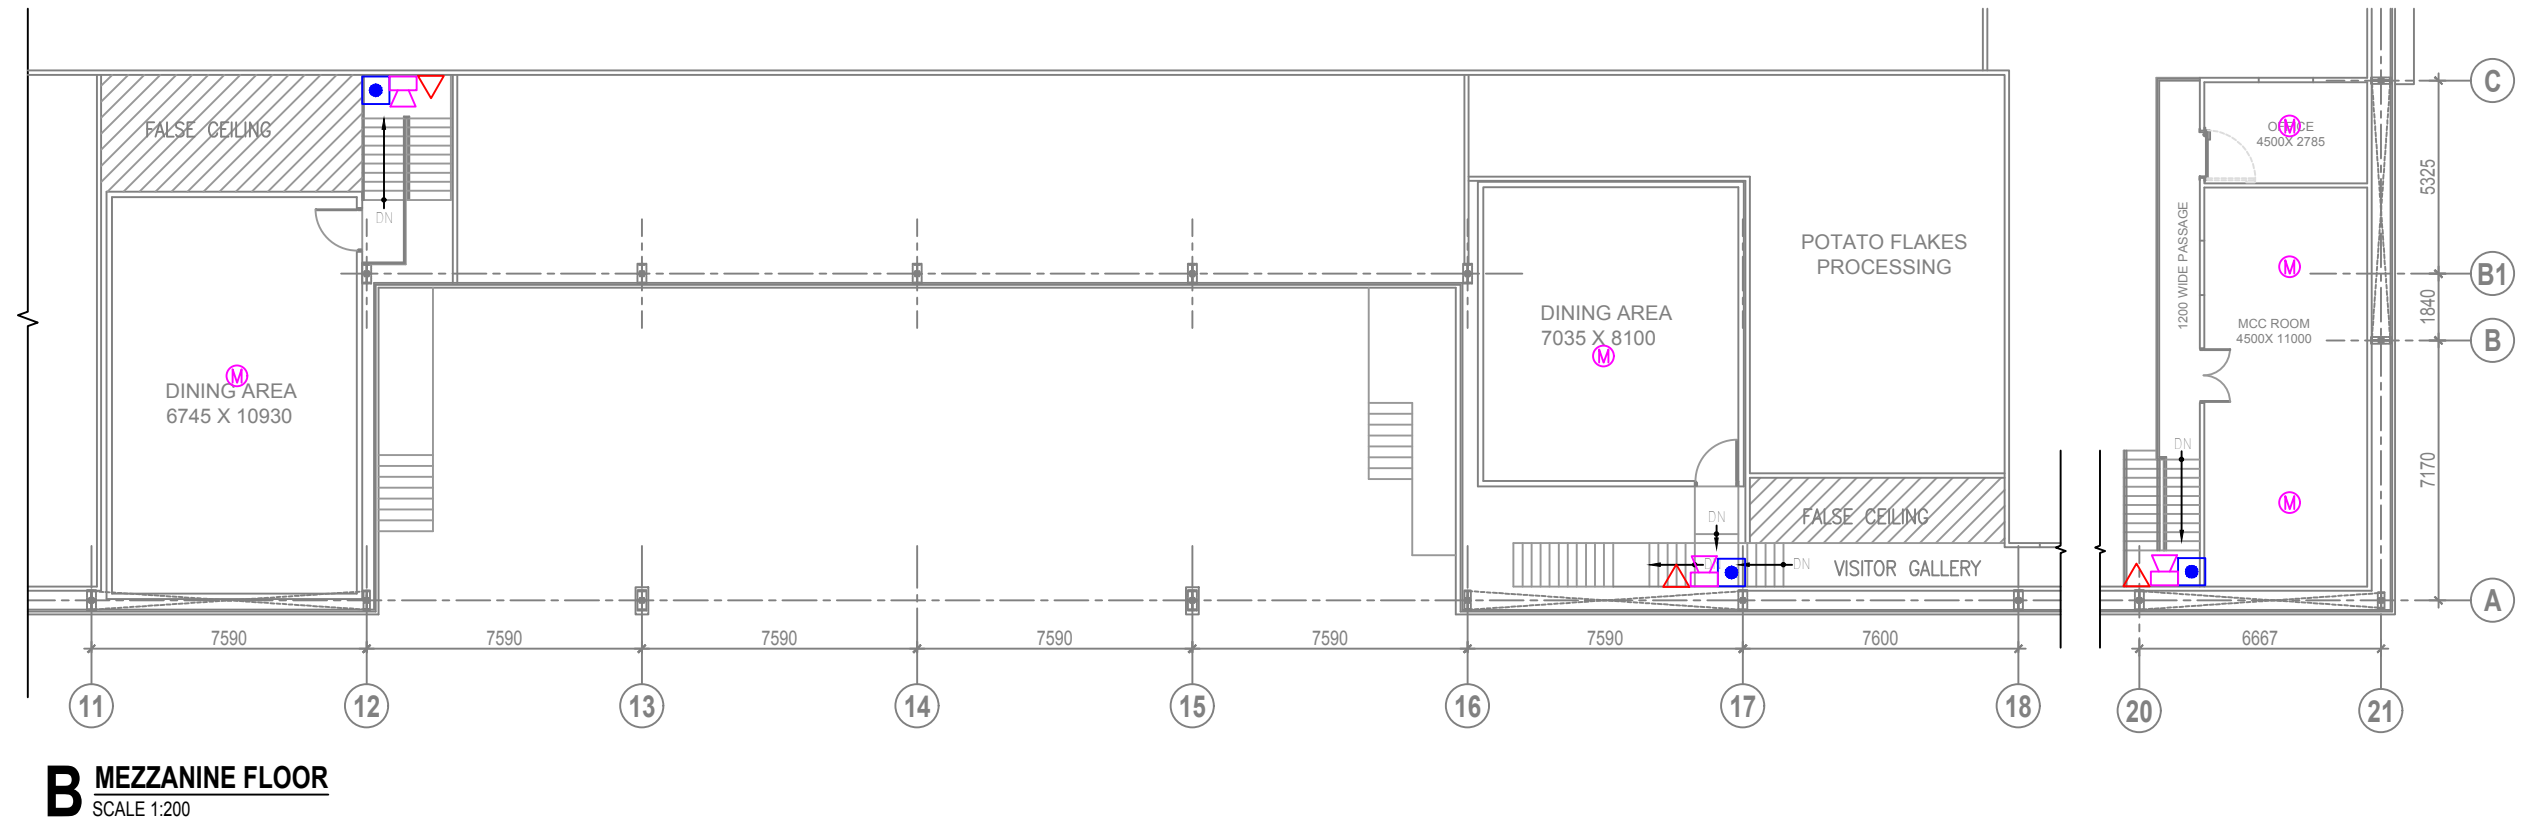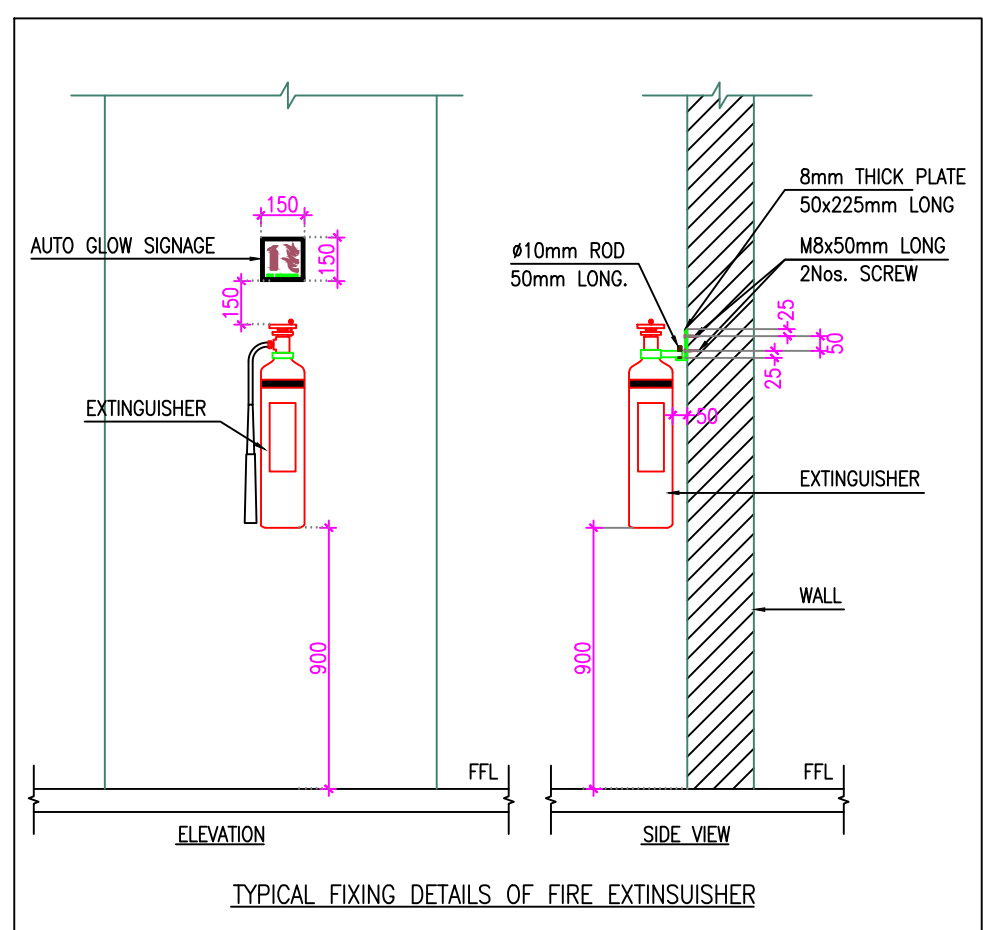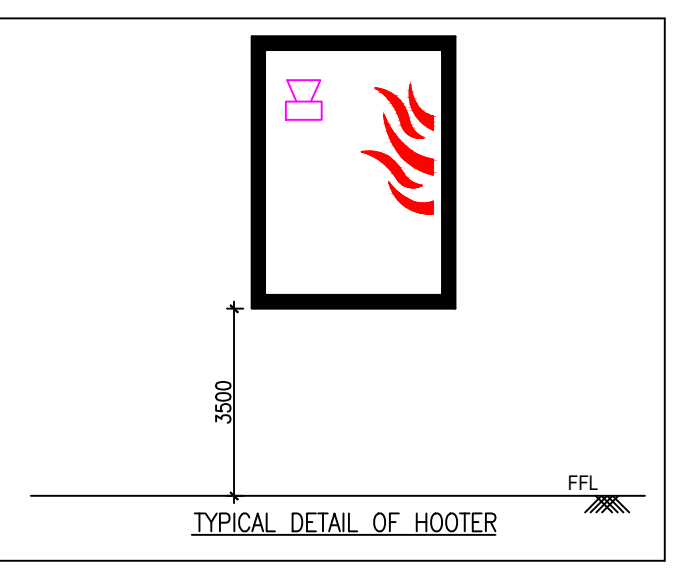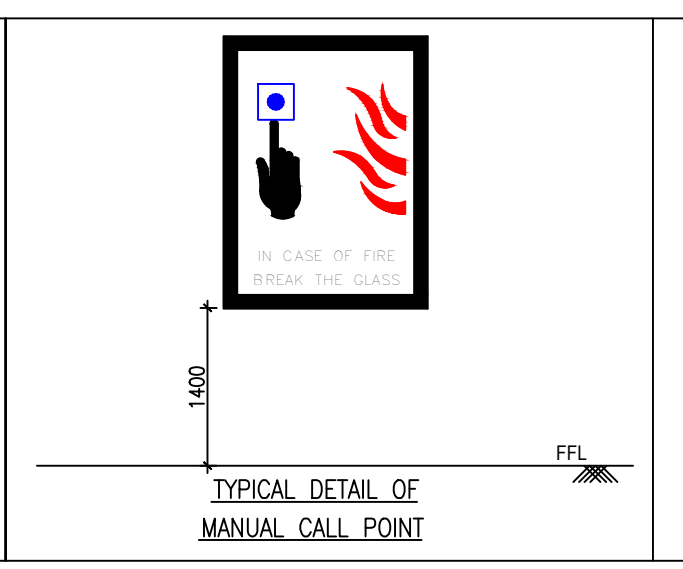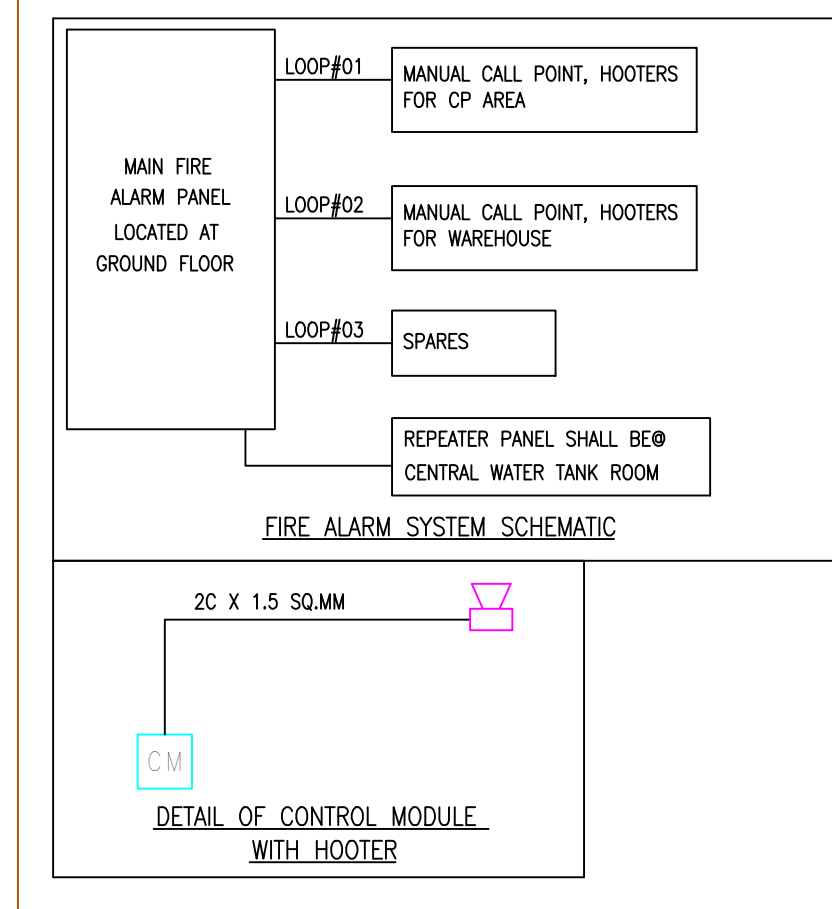

**B MEZZANINE FLOOR**  
SCALE 1:200