

THIS DRAWING & DESIGN IS THE SOLE PROPERTY OF VMS & SHALL NOT BE COPIED, TRACED OR REPRODUCED BY ANY MEANS WITHOUT PRIOR WRITTEN CONSENT OF THE FIRM.

GENERAL NOTES :


1. ALL DIMENSIONS ARE IN MM AND LEVELS ARE IN MT, UNLESS OTHERWISE MENTIONED.
2. ALL THE DIMENSIONS SHALL BE READ & NOT TO BE MEASURED.
3. IN CASE OF ANY DISCREPANCY, BRING IT TO THE NOTICE OF THE ARCHITECT IMMEDIATELY.

LEGEND LIST:

SR.NO.	SYMBOL	DESCRIPTION
01		SAD (SUPPLY AIR DUCT)
02		FAD (FRESH AIR DUCT)
03		EAD (EXHAUST AIR DUCT)
04		HI-WALL TYPE INDOOR UNIT-25KG
05		CASSETTE TYPE INDOOR UNIT-40KG
06		PROPELLER TYPE SUPPLY FAN-80KG
07		INLINE EXHAUST FAN-150KG
08		AIR CURTAIN-100KG
09		AIR CURTAIN-100KG
10		REFRIGERANT PIPE
11		DRAIN PIPE
12		SAG (SUPPLY AIR GRILLE)
13		FAG (SUPPLY AIR GRILLE)
14		EAG (EXHAUST AIR GRILLE)
15		PU (PRESSURIZATION UNIT)

NO.	DATE	DESCRIPTION	DRAWN BY	CHECKED BY
R0	22-05-19	ISSUED FOR TENDER	KRUNAL	AJAY

REVISION HISTORY

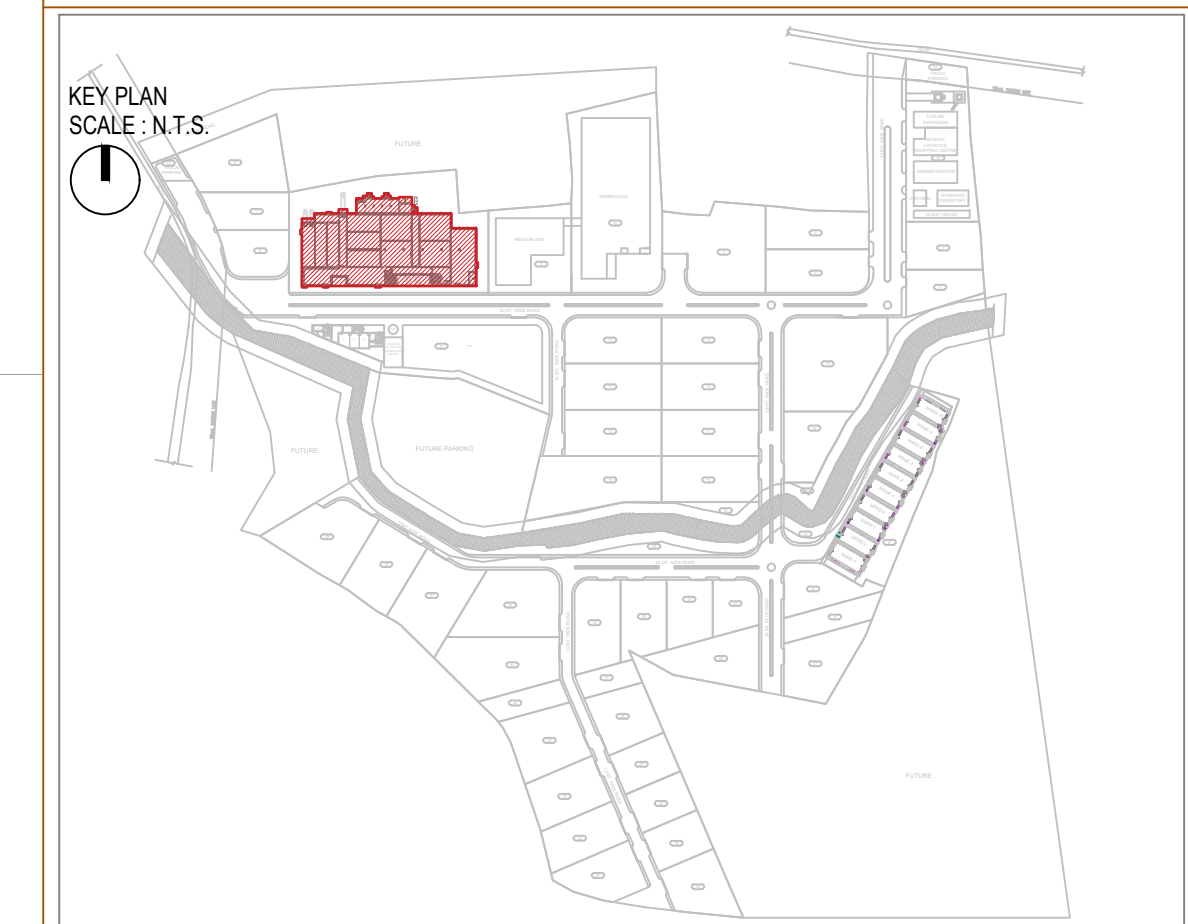

REFERENCE DRAWINGS :

- 01. ARCHITECTURAL :-
- 02. STRUCTURAL :-
- 03. HVAC :-
- 04. ELECTRICAL :-
- 05. UTILITIES :-

HVAC LAYOUT FOR GR. & MEZZ. FLOOR

CP AREA



PMC
Technopak Advisors Pvt. Ltd.
Gurgaon.

fanidhar
MEGA FOOD PARK - AT MUDARDA, MEHSANA
kheta se bazaar tak

PROJECT NO.	SCALE :	DRAWN :	KRUNAL
2017	1:200	CHECKED :	AJAY
DATE :	22-05-2019	APPROVED :	NANCY
		COORDINATION CHECKED :	NITESH

vms VMS ENGINEERING & DESIGN SERVICES (P) LTD.
CHITRAKOOT FLATS, BEHIND TIMES OF INDIA, OFF ASHRAM ROAD,
AHMEDABAD-380 009. PHONE: +91 (079) 2658-8234/4488, 40238236
ENGINEERING + ARCHITECTURE FAX: +91 (079) 2658 3598 WWW.VMSCONSULTANTS.COM

SHEET SIZE	DRAWING NO.	RELEASED FOR	REVISION:
600x1000	MH.40B.401	T	R0

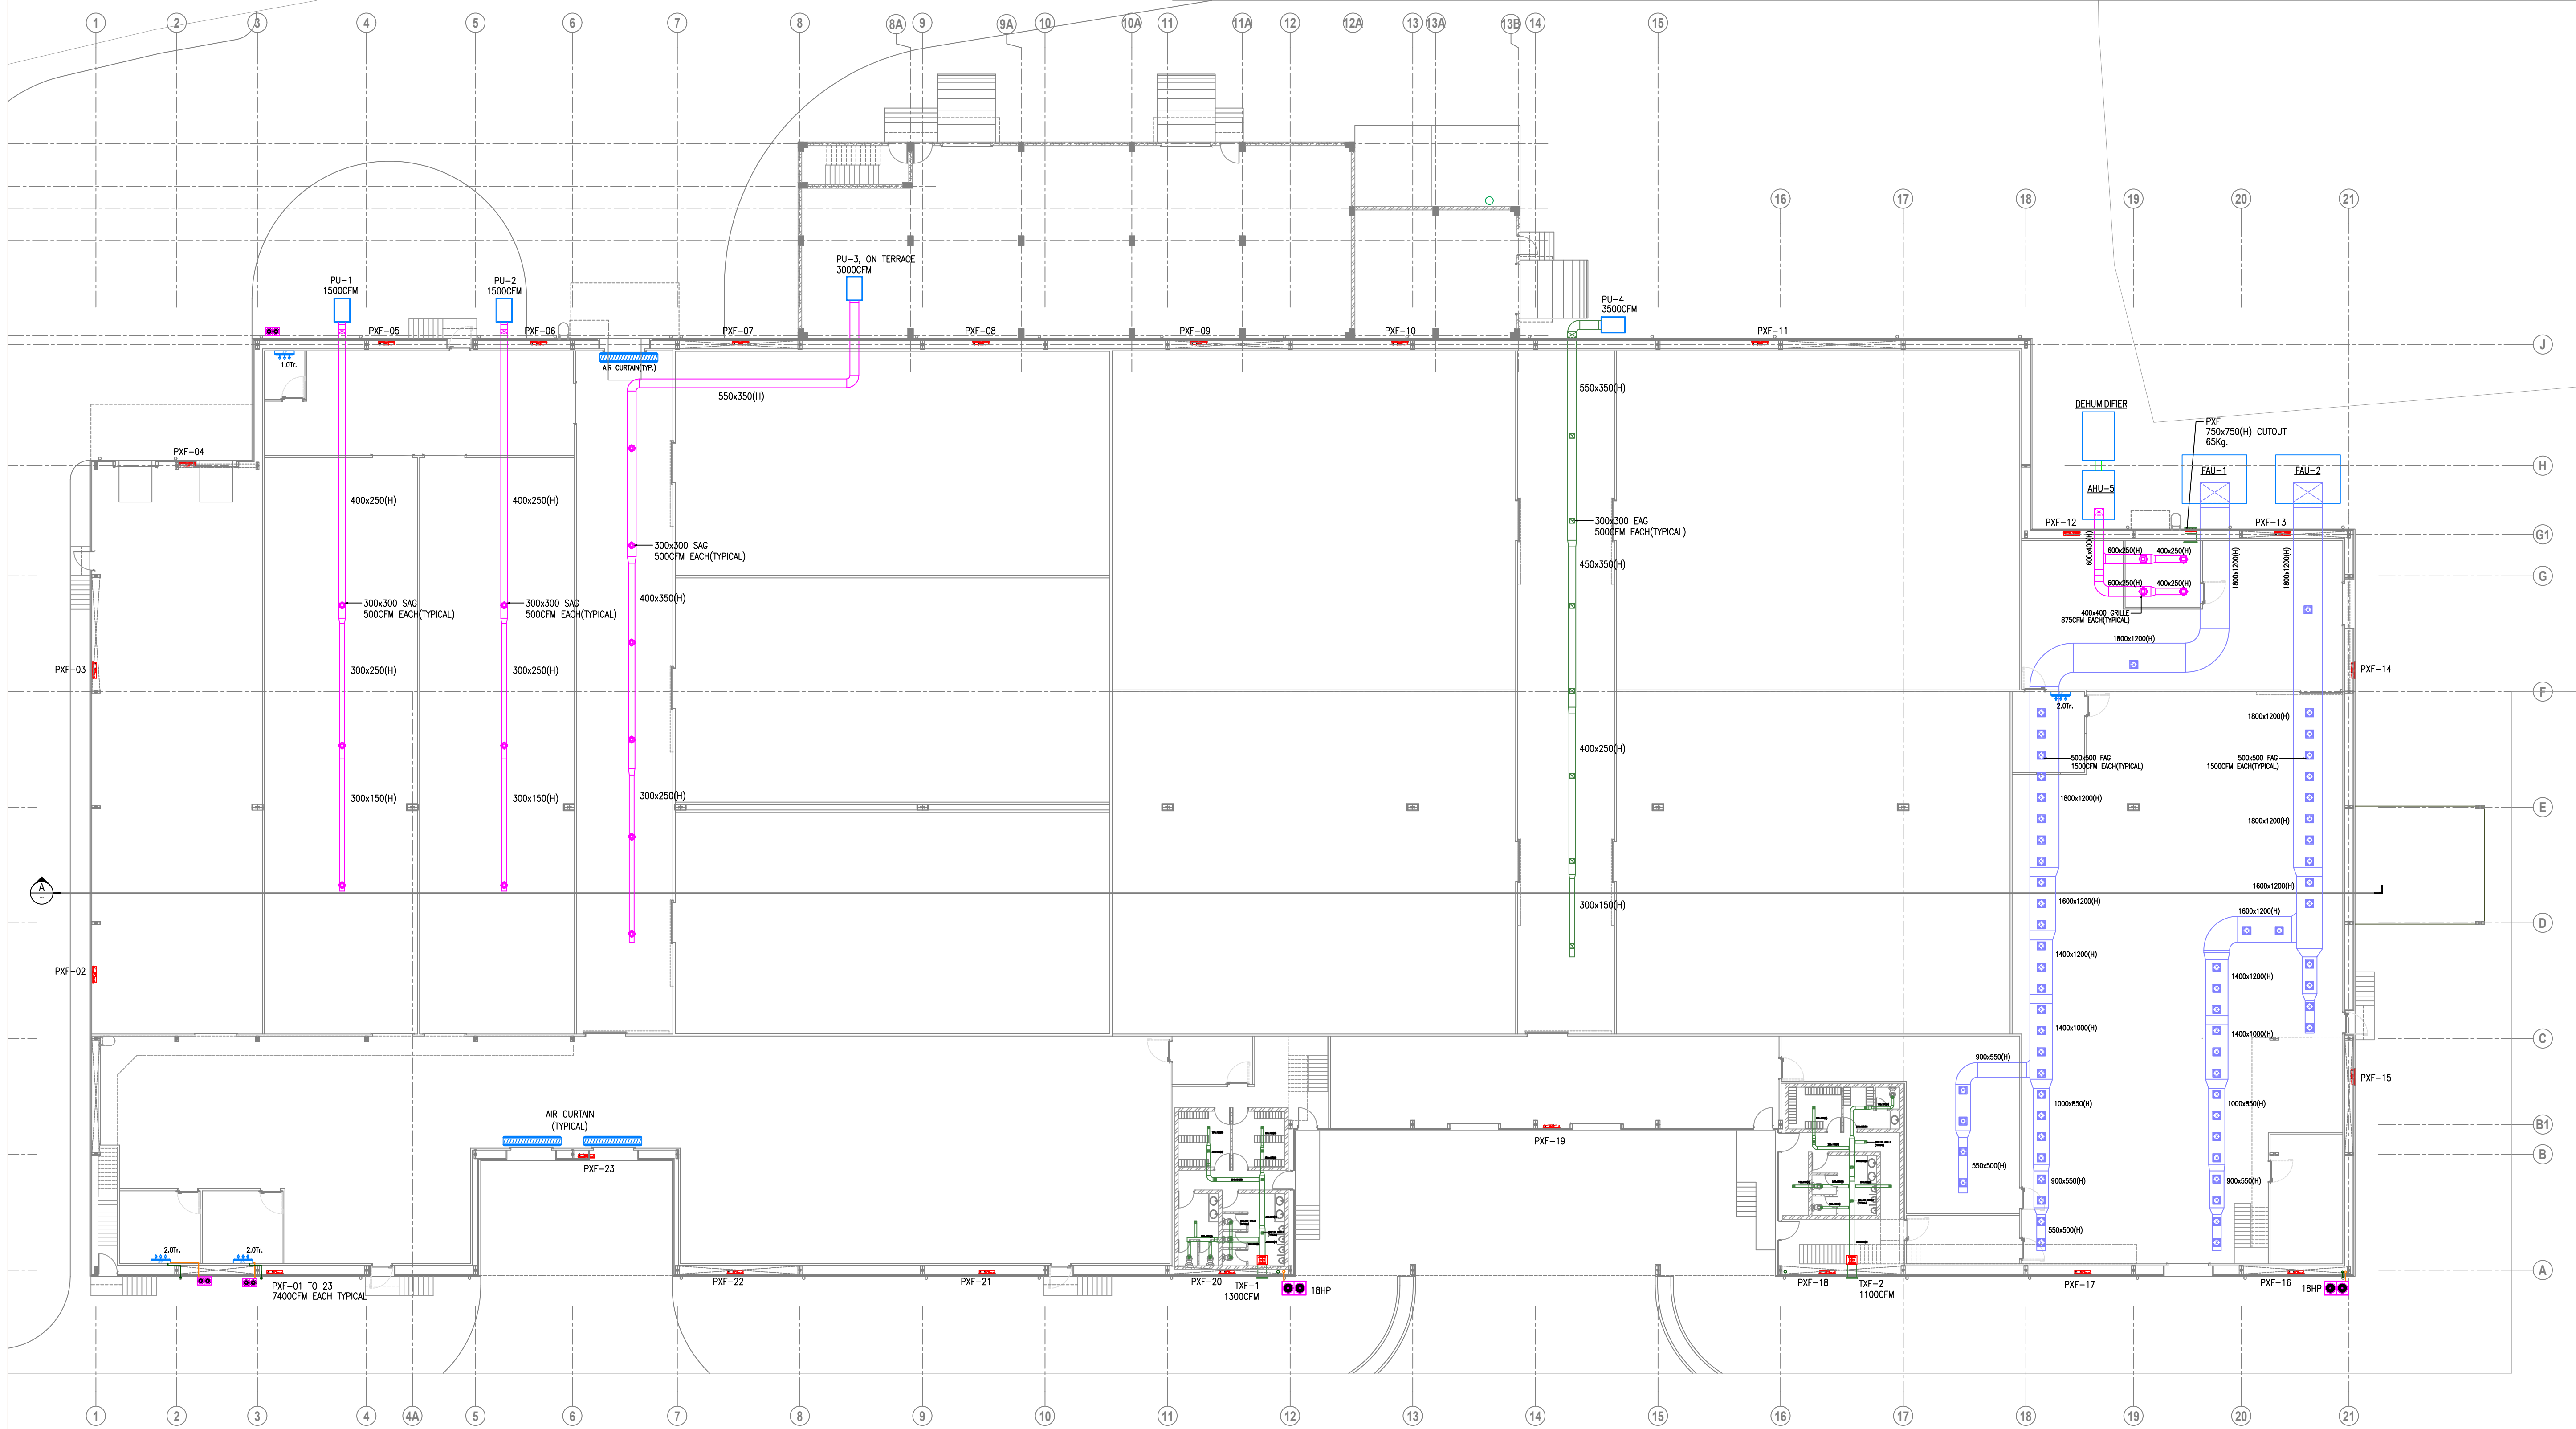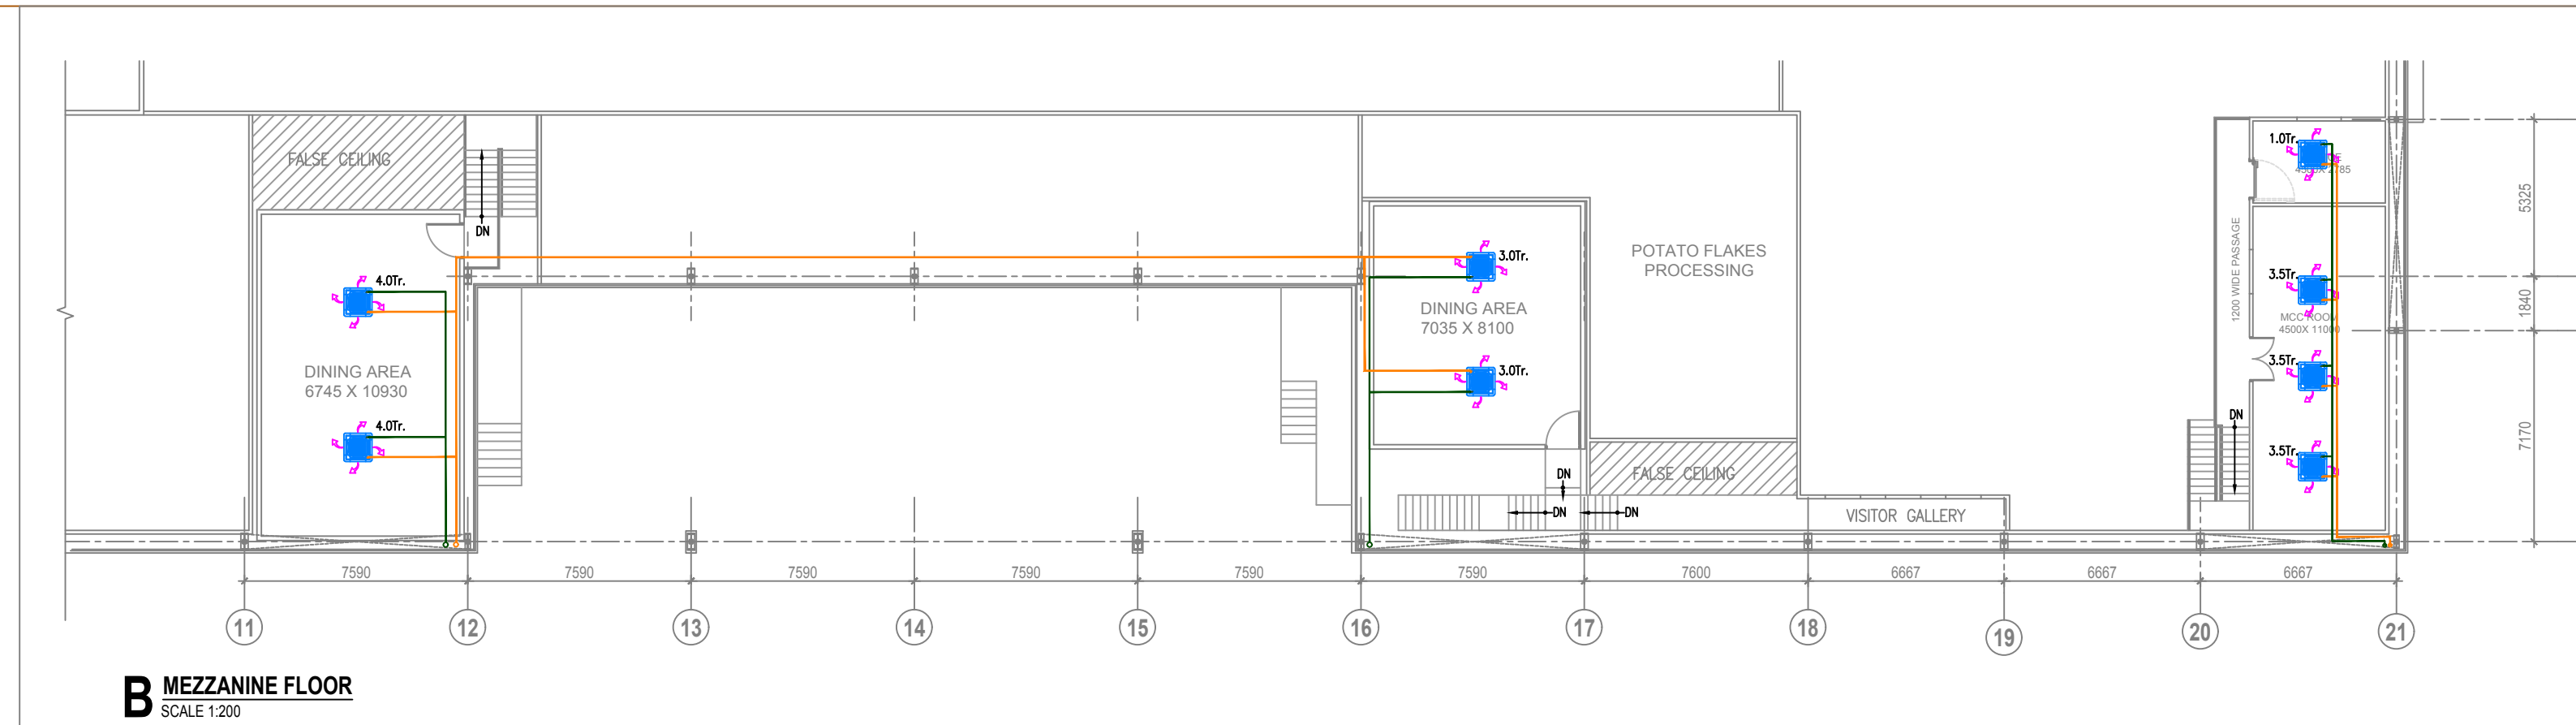

A GROUND FLOOR PIPING & DUCT LAYOUT
SCALE 1:200